



Accepted by: _____ Date: _____


All measurements are approximate and may be adjusted on site. All renderings are conceptual only, refer to written contract for actual specifications.

Josh Prine and Stephanie
1045 E King Street
Franklin, IN



DRAWINGS PROVIDED BY:
Karen Shreves
karen@midwest-remodeling.com
765-776-5411


DATE:
11/19/2024
SCALE:
SHEET:

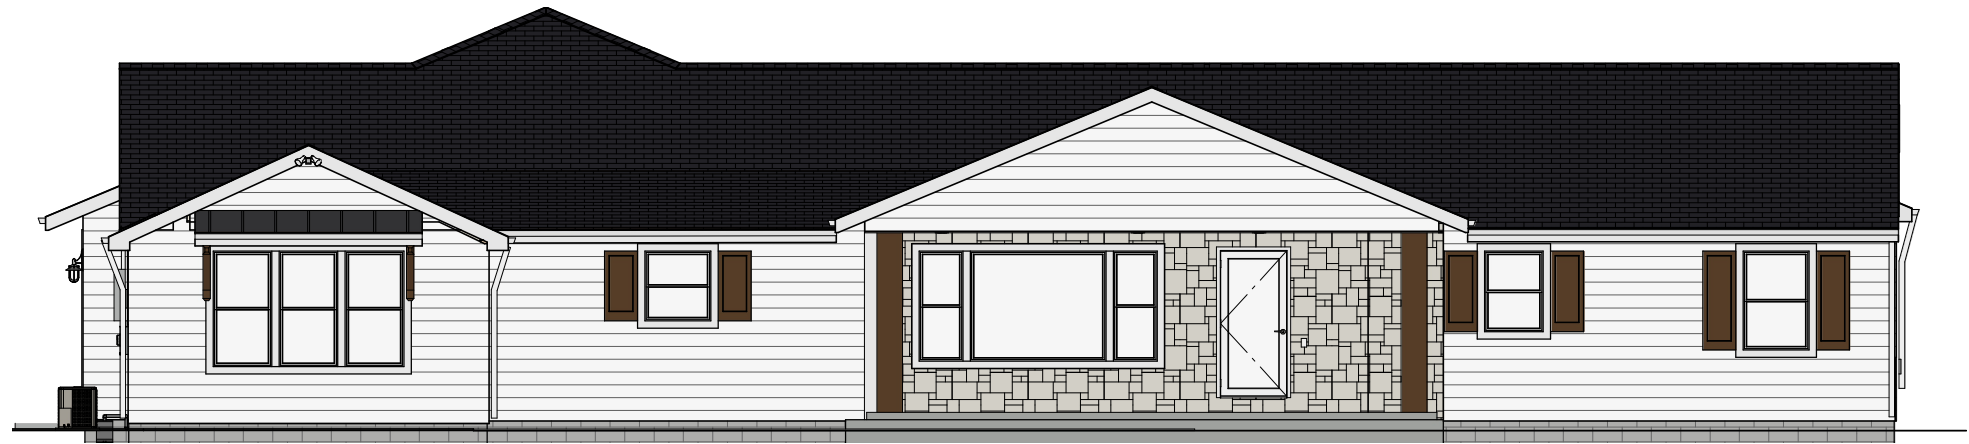

Front Elevation



Left Elevation

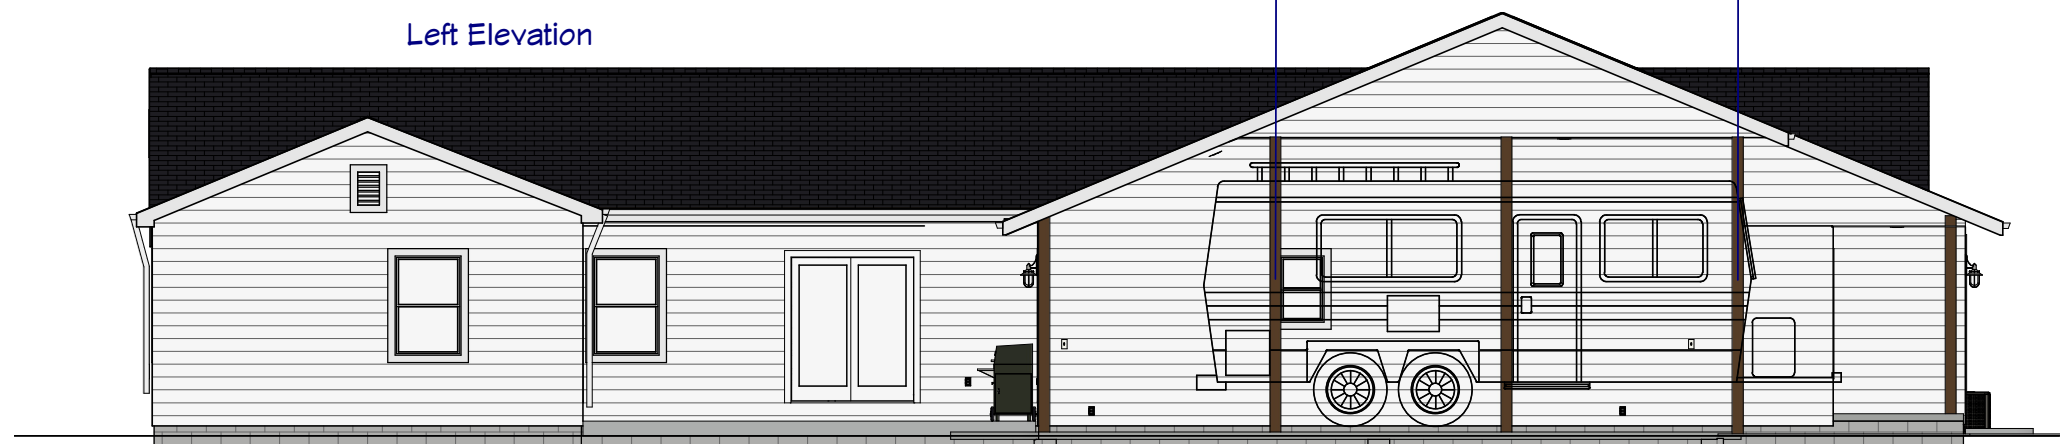

Rear Elevation



Right Elevation

Accepted by: _____ Date: _____

All measurements are approximate and may be adjusted on site. All renderings are conceptual only, refer to written contract for actual specifications.

Josh Prine and Stephanie
1045 E King Street
Franklin, IN


Midwest
Remodeling

DRAWINGS PROVIDED BY:
Karen Shreves
karen@midwest-remodeling.com
765-776-0411

DATE:

11/19/2024

SCALE:

SHEET:

AFTER Nancy's KITCHEN



Josh Prine and Stephanie
1045 E King Street
Franklin, IN


Midwest
Remodeling

DRAWINGS PROVIDED BY:
Karen Shreve
karen@midwest-remodeling.com
765-776-5411

DATE:

11/19/2024

SCALE:

SHEET:

Accepted by: _____

Date: _____

All measurements are approximate and may be adjusted on site. All renderings are conceptual only, refer to written contract for actual specifications.

AFTER
Nancy's
BATHROOM



Josh Prine and Stephanie
1045 E King Street
Franklin, IN



DRAWINGS PROVIDED BY:
Karen Shreve
karen@midwest-remodeling.com
765-776-5411

DATE:

11/19/2024

SCALE:


SHEET:

Accepted by: _____

Date: _____

All measurements are approximate and may be adjusted on site. All renderings are conceptual only, refer to written contract for actual specifications.

FRAMING

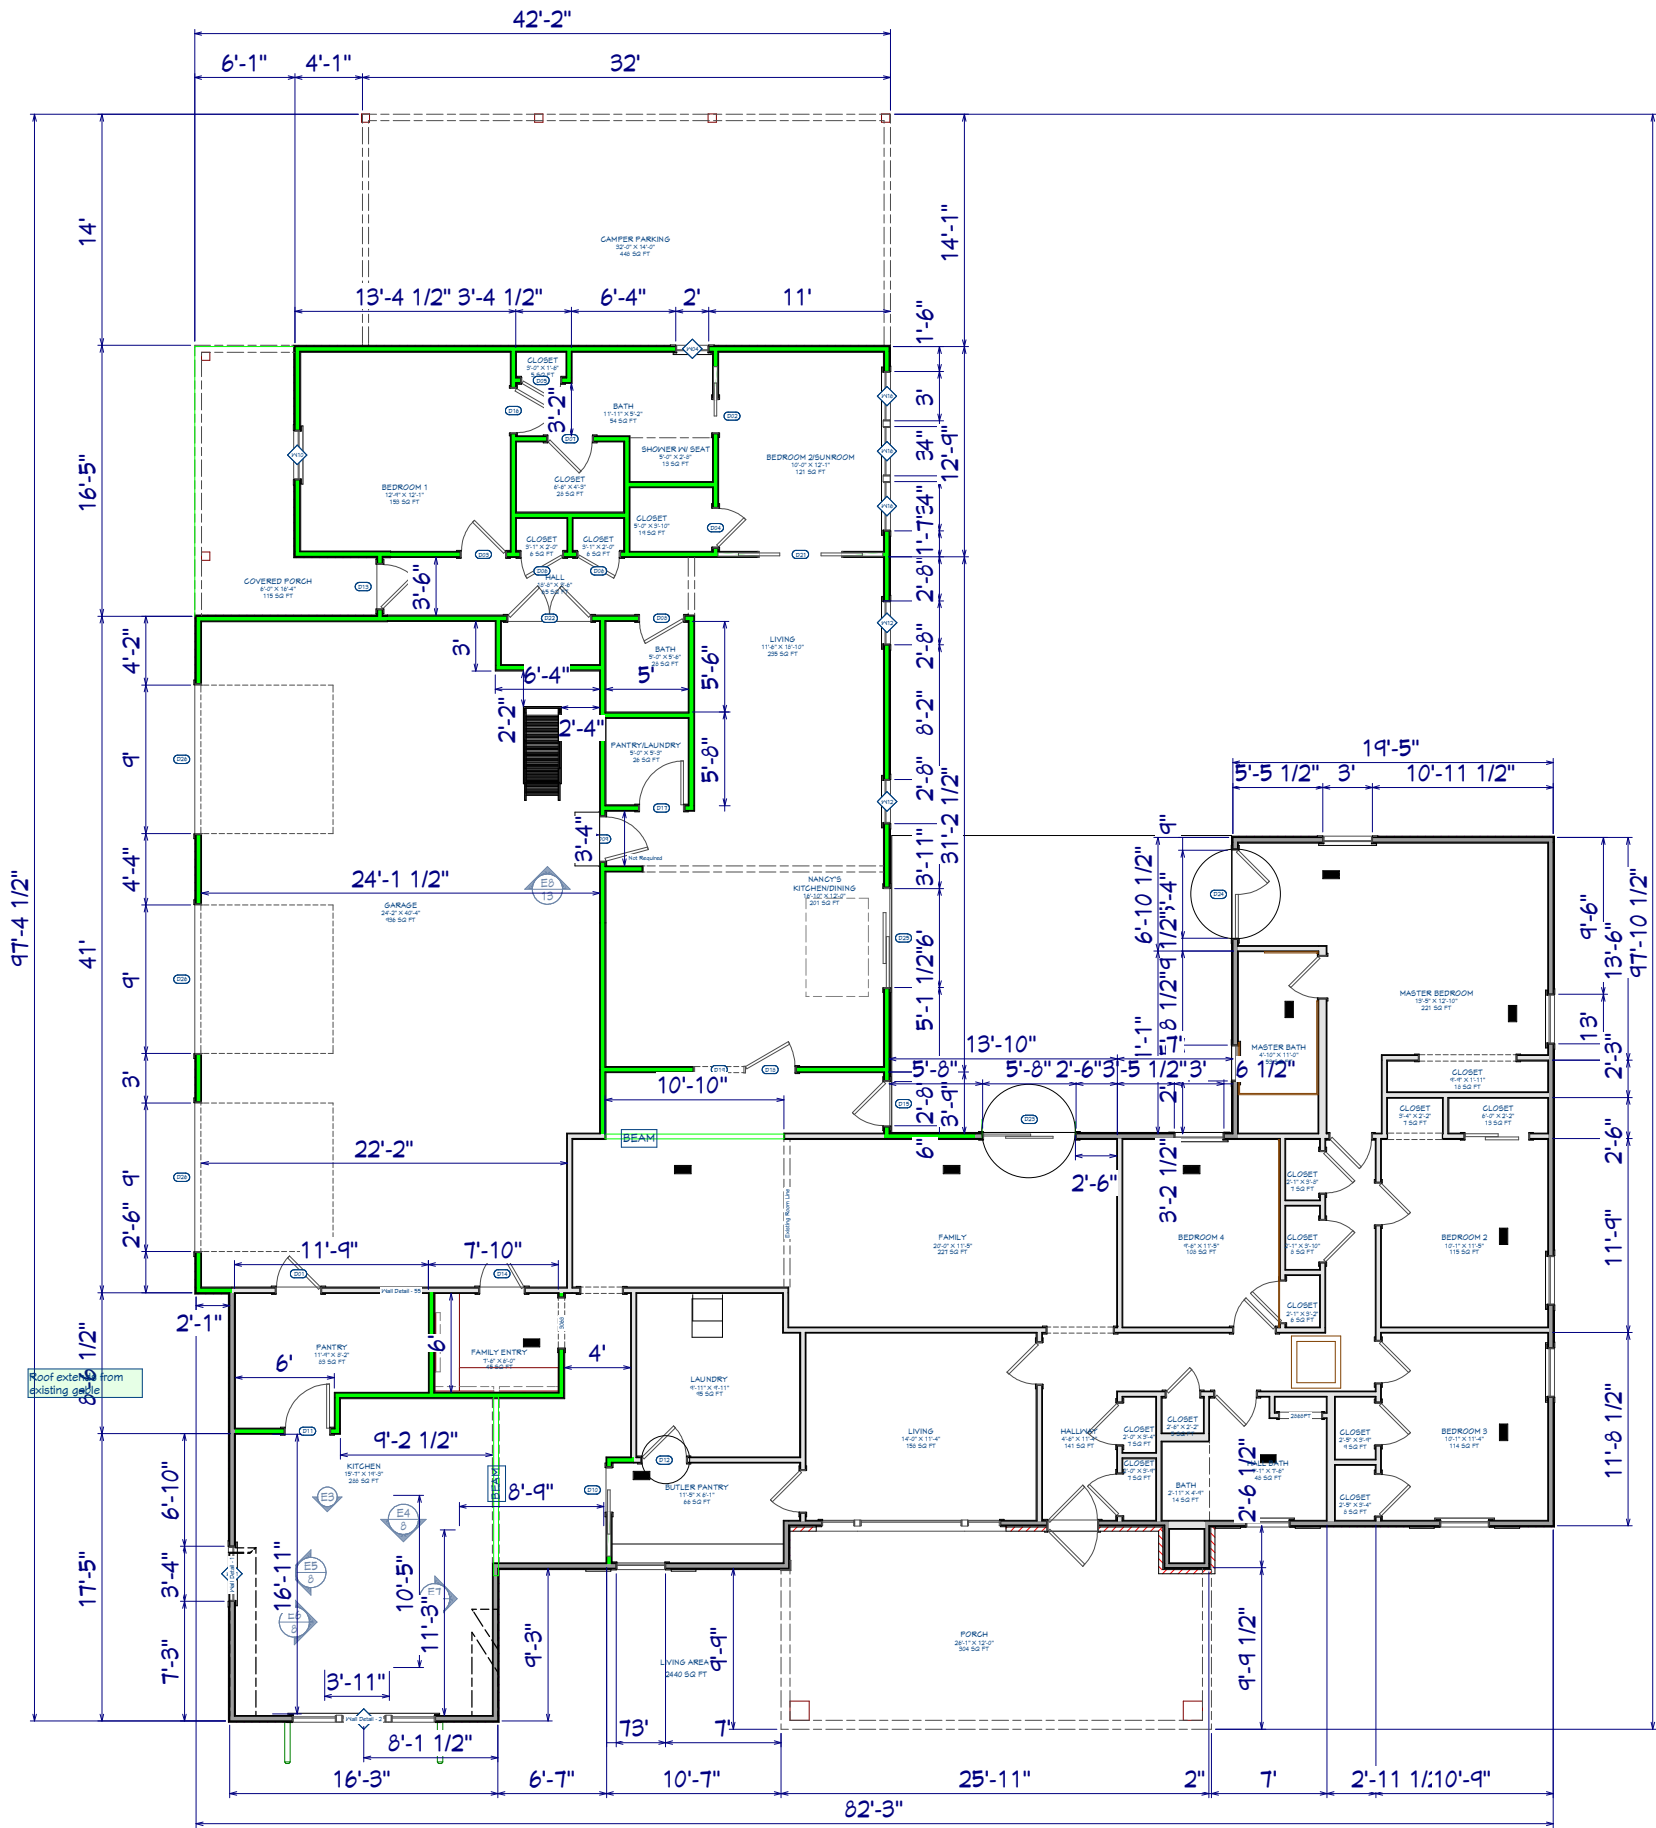

		DOOR SCHEDULE			
NUMBER	QTY	ROOM NAME	WIDTH	DESCRIPTION	COMMENTS
D01	1	PANTRY/GARAGE	32"	EXT. HINGED-SLAB	
D02	1	BATH/BEDROOM 2/SUNROOM	24"	POCKET-DOOR P04	
D03	1	BEDROOM 1/HALL	32"	HINGED-DOOR P04	
D04	1	CLOSET/BEDROOM 2/SUNROOM	28"	HINGED-DOOR P04	
D05	1	BATH/CLOSET	28"	HINGED-DOOR P04	
D06	2	CLOSET/HALL	30"	EXT. HINGED-DOOR E21	
D07	1	CLOSET/BATH	32"	HINGED-DOOR P04	
D08	1	HALL/BATH	32"	HINGED-DOOR P04	
D09	1	LIVING/GARAGE	32"	HINGED-DOOR P04	
D10	1	BUTLER PANTRY/KITCHEN	32"	POCKET-DOOR P04	
D11	1	PANTRY/KITCHEN	32"	HINGED-DOOR P04	
D12	1	LAUNDRY/BUTLER PANTRY	32"	HINGED-SLAB	INCREASE TO 32" AND CHANGE SWING
D13	1	HALL/COVERED PORCH	32"	EXT. HINGED-DOOR E21	
D14	1	FAMILY ENTRY/GARAGE	32"	EXT. HINGED-DOOR P04	
D15	1	DINING	32"	EXT. HINGED-GLASS PANEL	
D16	1	BATH/BEDROOM 1	32"	HINGED-DOOR P04	
D17	1	PANTRY/LAUNDRY/LIVING	32"	HINGED-DOOR P04	
D18	1	NANCY'S KITCHEN/DINING/DINING	36"	HINGED-DOOR P04	
D19	1	NANCY'S KITCHEN/DINING/DINING	36"	DOORWAY	FRAME FOR EVENTUAL LARGE OPENING
D21	1	BEDROOM 2/SUNROOM/LIVING	60"	DOUBLE POCKET-DOOR P04	
D22	1	HALL/CLOSET	60"	DOUBLE HINGED-DOOR P04	
D23	1	FAMILY	68"	EXT. SLIDER-GLASS PANEL	REPLACE WINDOWS WITH SLIDER (USE EXISTING HEADER)
D24	1	MASTER BEDROOM	64"	EXT. DOUBLE HINGED-DOOR F01	
D25	1	NANCY'S KITCHEN/DINING	72"	EXT. SLIDER-GLASS PANEL	
D26	3	GARAGE	108"	GARAGE-GARAGE DOOR CHD05	

		WINDOW SCHEDULE				
NUMBER	QTY	ROOM NAME	WIDTH	HEIGHT	DESCRIPTION	COMMENTS
W01	1	KITCHEN	104"	63"	MULLED UNIT	
W04	1	BATH/CAMPER PARKING	24"	36"	DOUBLE HUNG	
W10	1	BEDROOM 1/COVERED PORCH	36"	63"	DOUBLE HUNG	
W11	1	KITCHEN	40"	36"	SINGLE AWNING	
W12	2	LIVING	32"	63"	DOUBLE HUNG	
W16	3	BEDROOM 2/SUNROOM	36"	63"	DOUBLE HUNG	

Josh Prine and Stephanie
1045 E King Street
Franklin, IN



DRAWINGS PROVIDED BY:
Karen Streeves
Karen@Midwest-Remodeling.com
765-776-0411

DATE:
11/19/2024


SCALE:

SHEET:

Accepted by: _____ Date: _____

All measurements are approximate and may be adjusted on site. All renderings are conceptual only, refer to written contract for actual specifications.

ROOF

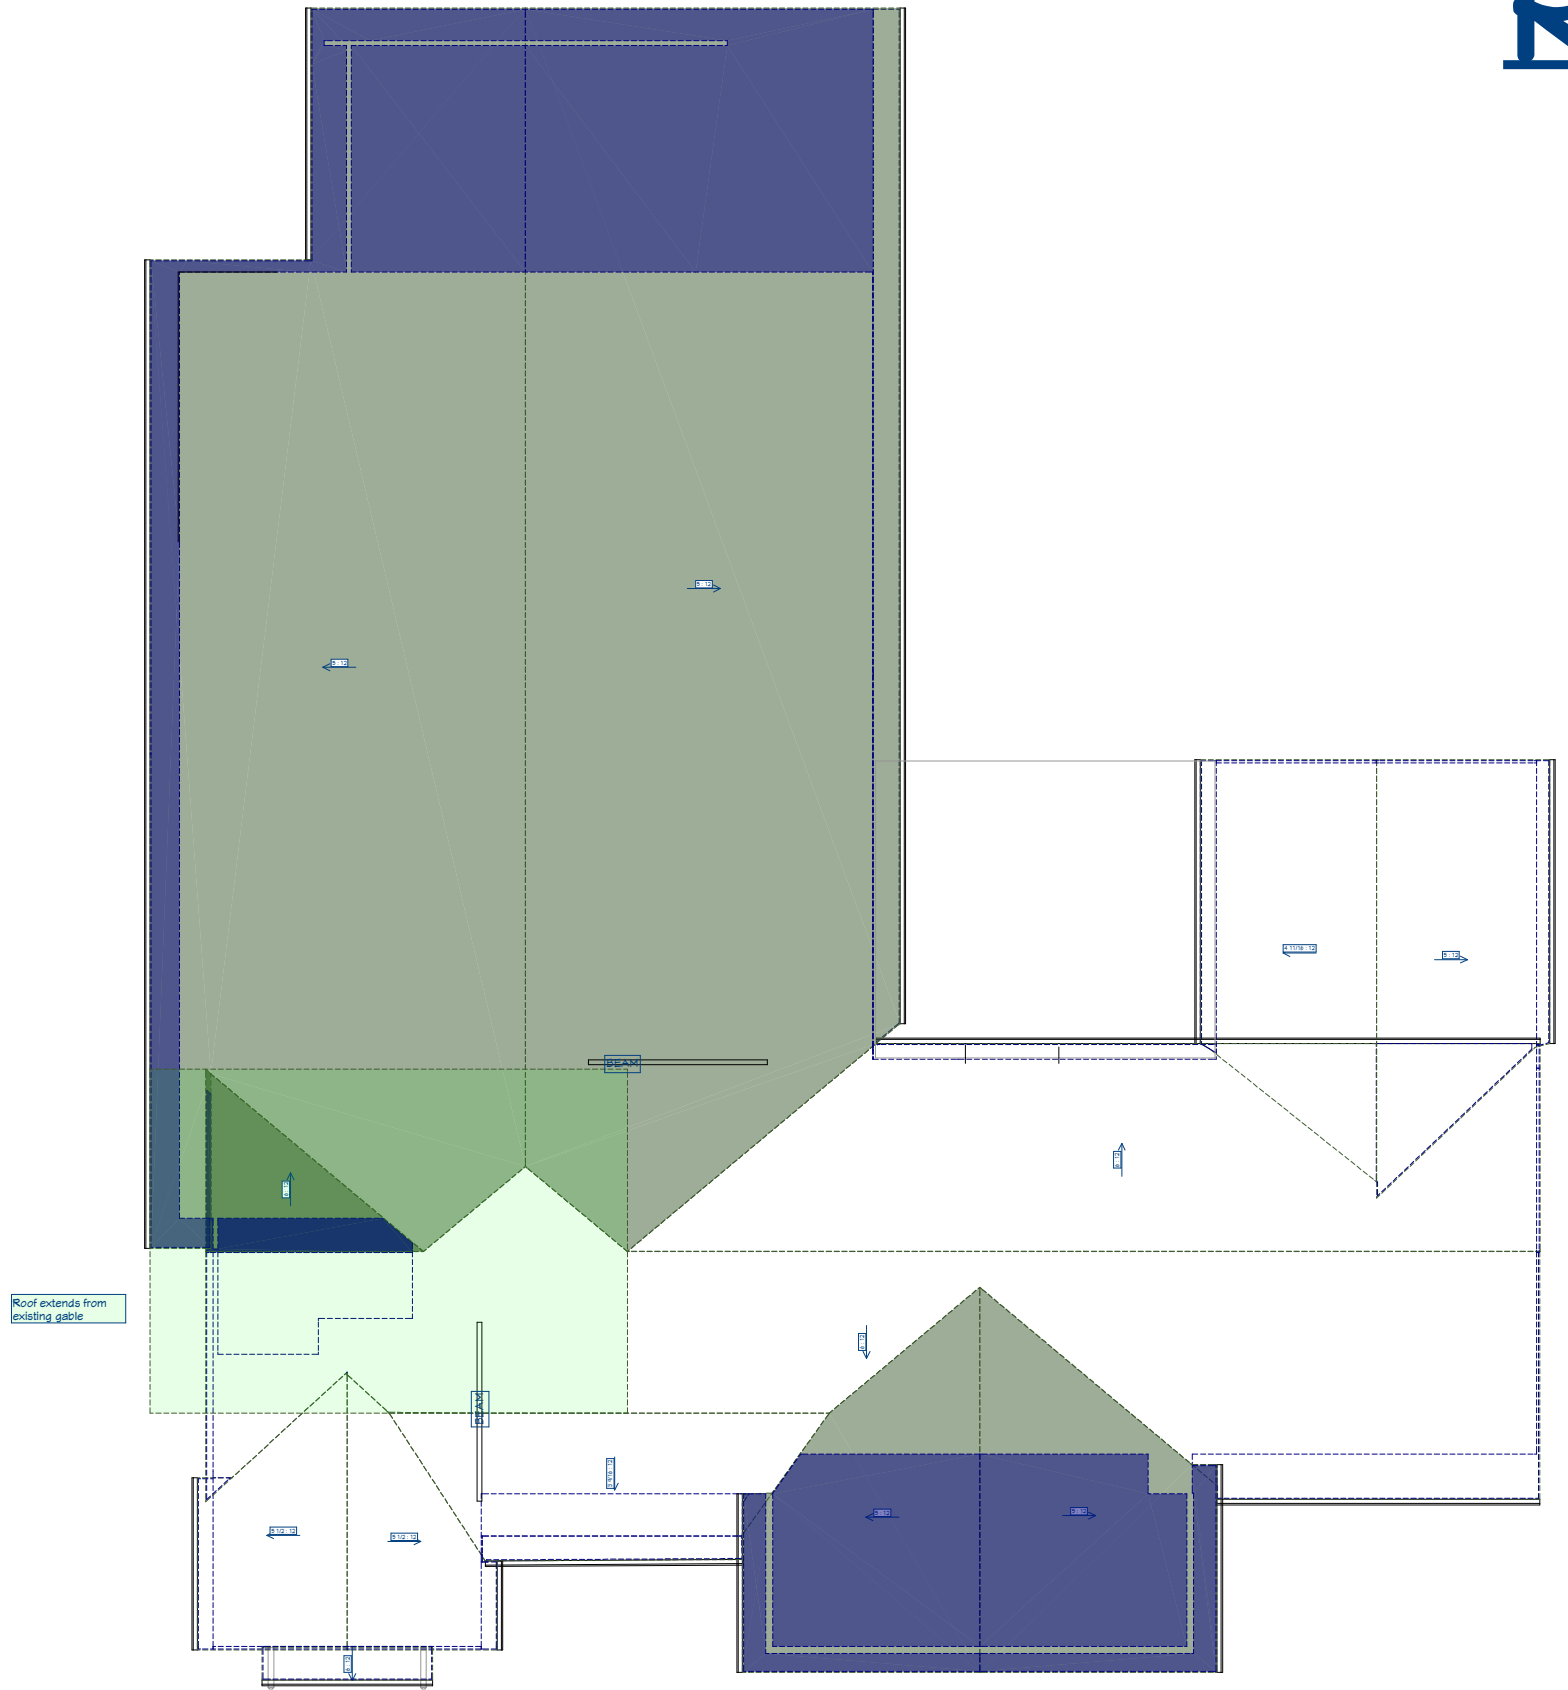

Accepted by: _____ Date: _____


All measurements are approximate and may be adjusted on site. All renderings are conceptual only, refer to written contract for actual specifications.

Josh Prine and Stephanie
1045 E King Street
Franklin, IN




DRAWINGS PROVIDED BY:
Karen Shreeves
karen@midwest-remodeling.com
765-776-0411

DATE:
11/19/2024
SCALE:
SHEET:

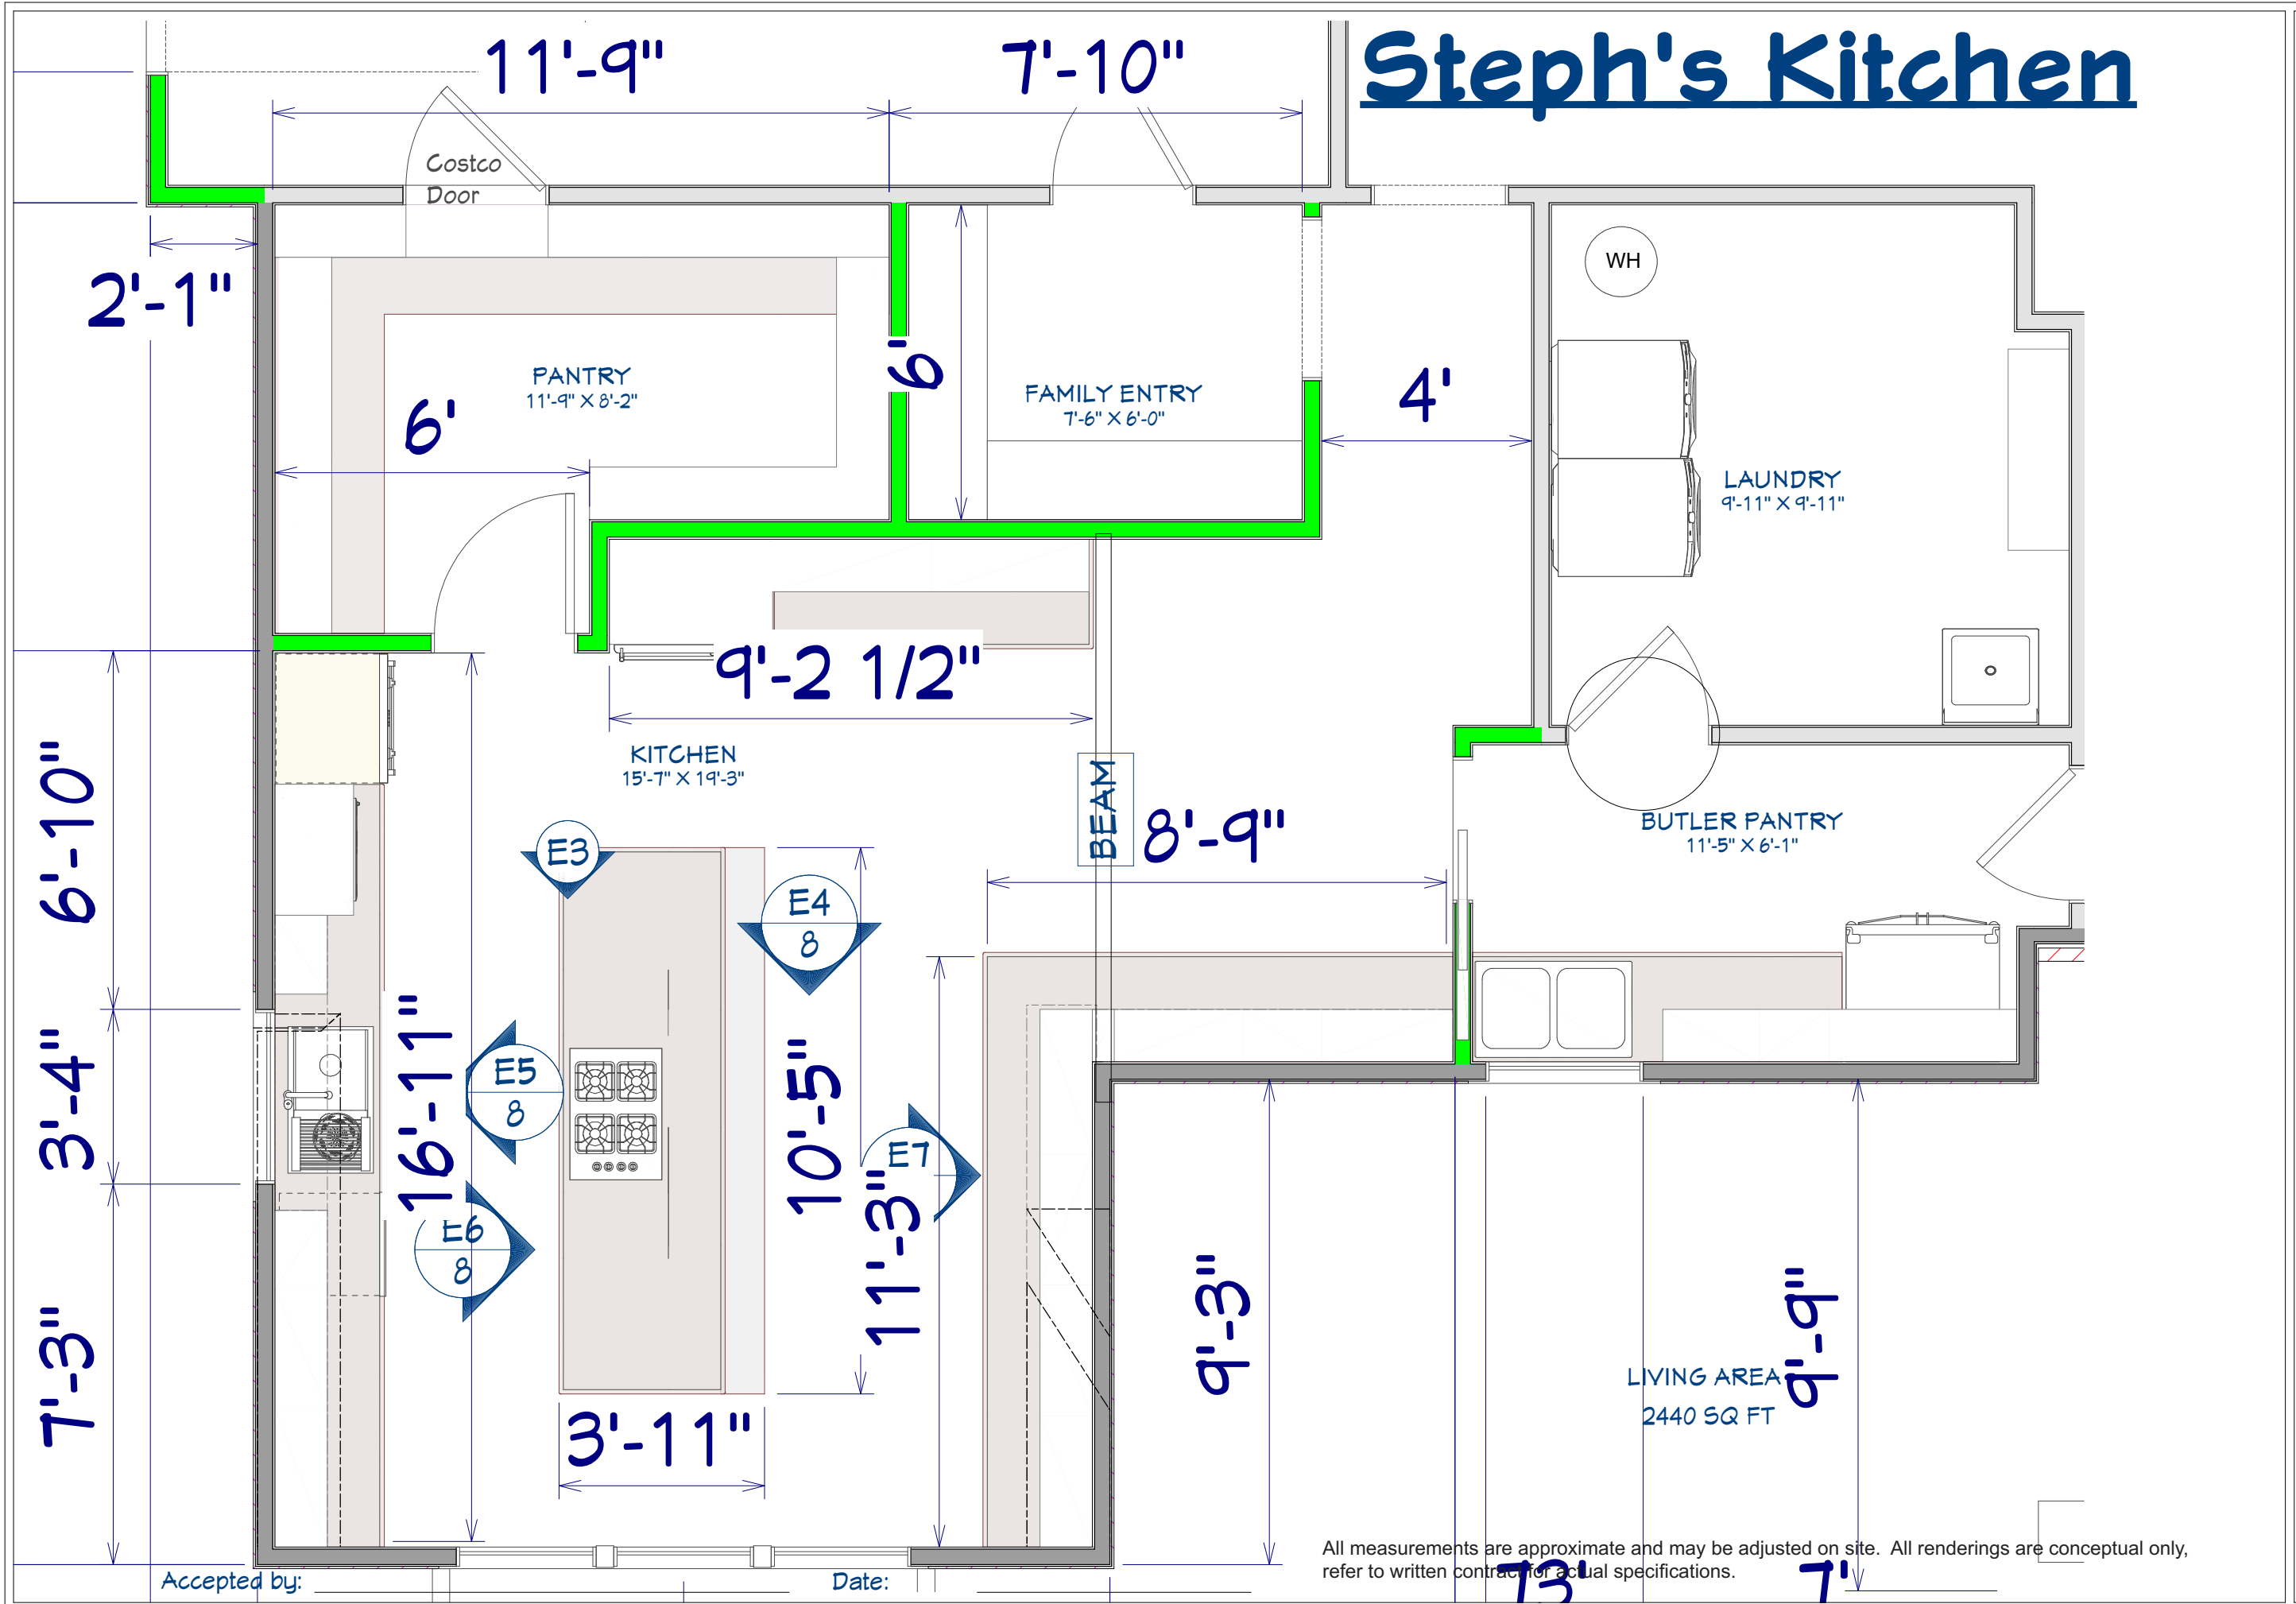

All measurements are approximate and may be adjusted on site. All renderings are conceptual only, refer to written contract for actual specifications.

Josh Prine and Stephanie
1045 E King Street
Franklin, IN

**Midwest
Remodeling**


DRAWINGS PROVIDED BY:
Karen Shreves
Karen@Midwest-Remodeling.com
765-776-0411

DATE:
11/19/2024

SCALE:
1" = 1'-0"

SHEET:
1 of 1


Steph's Kitchen

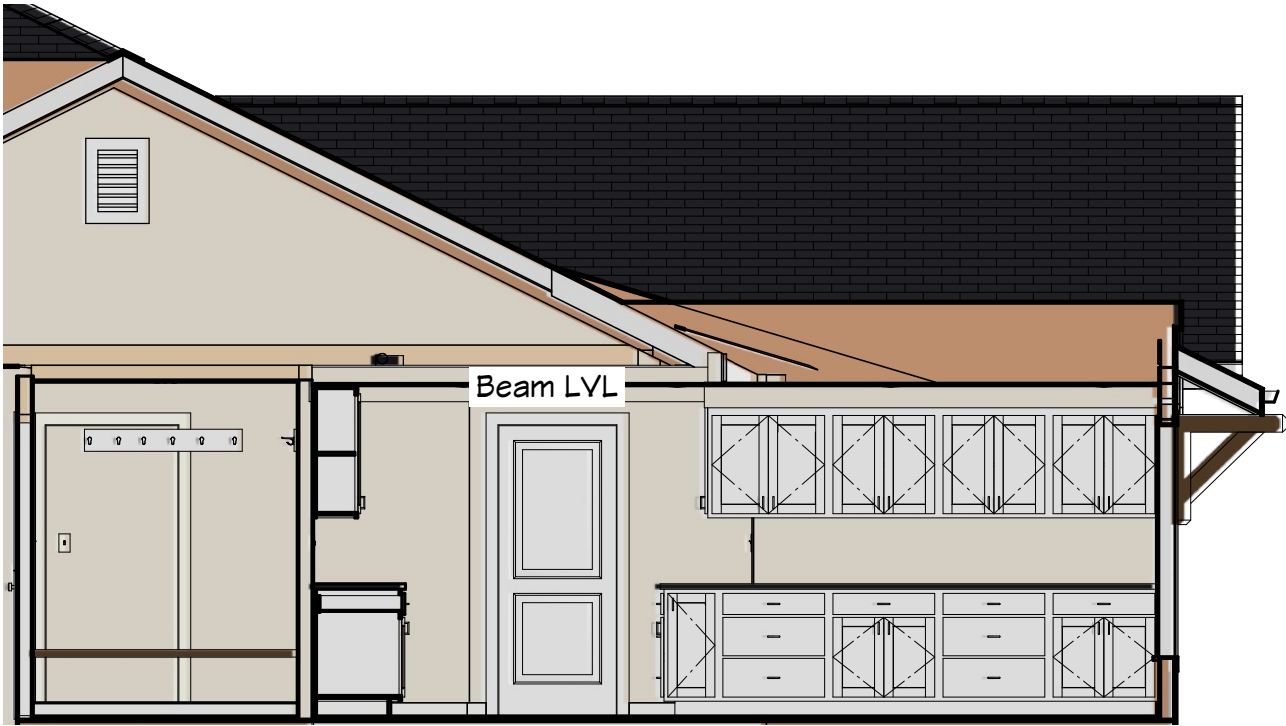


Elevation 7



Elevation 4

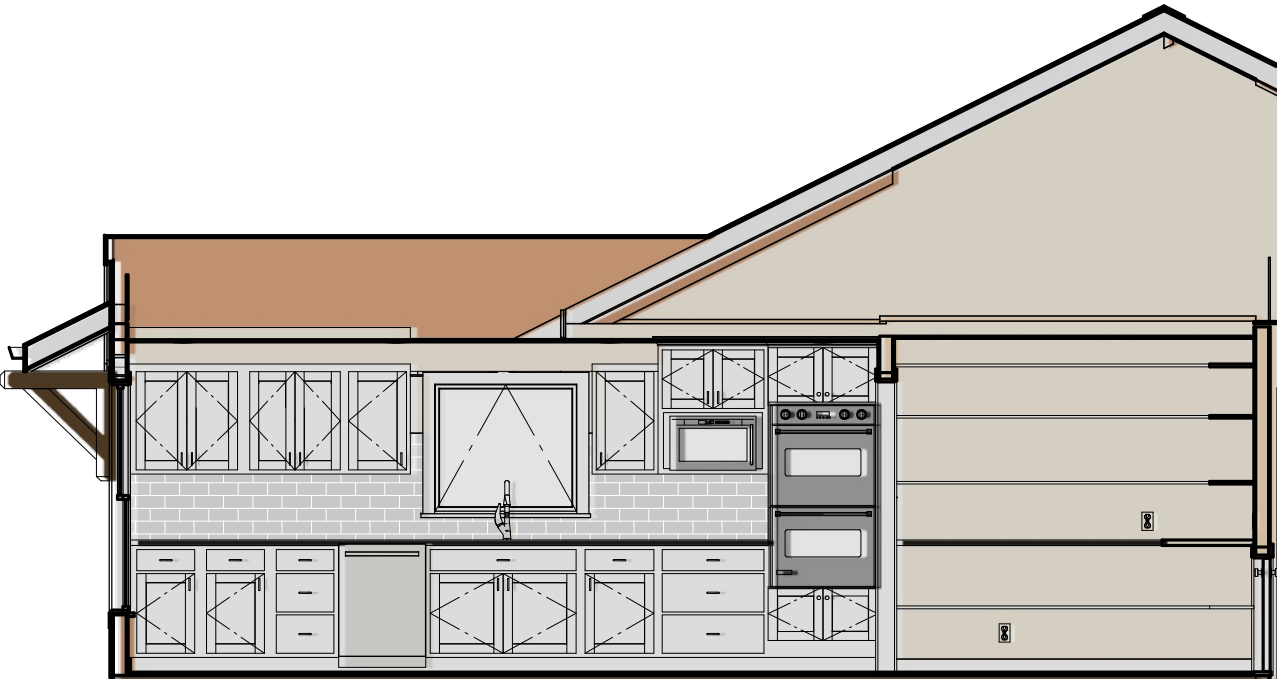

Elevation 5

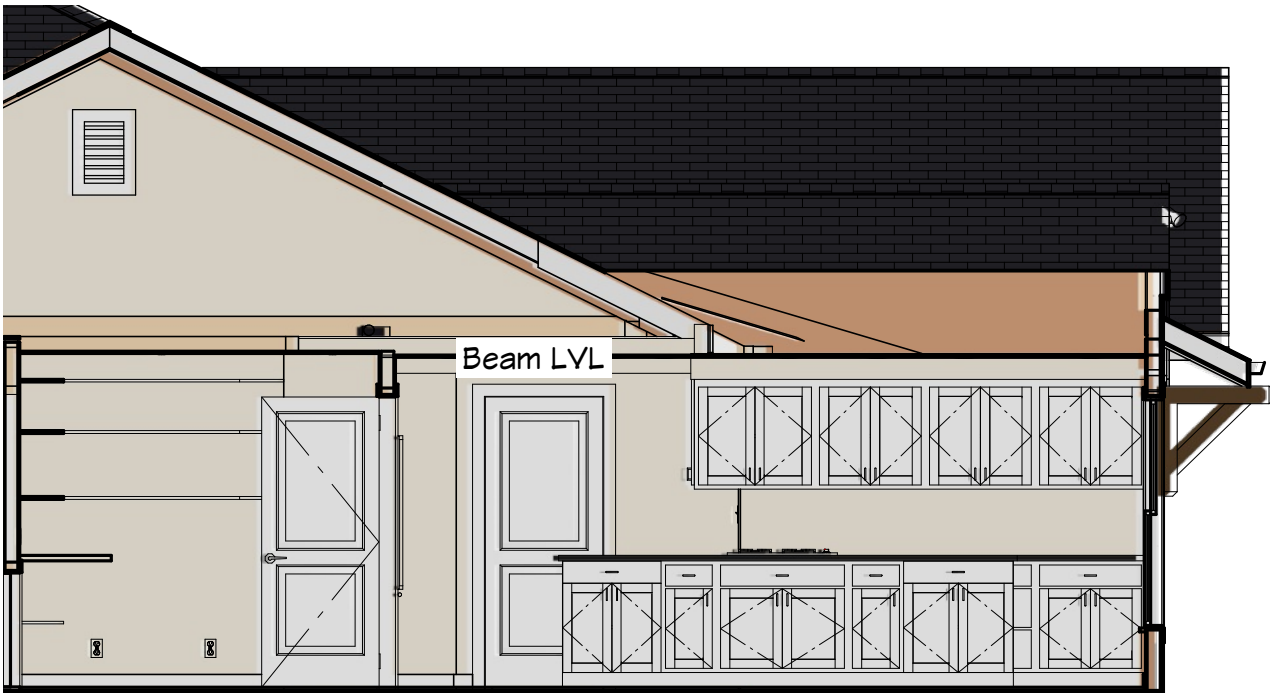

Elevation 6

Accepted by: _____ Date: _____

All measurements are approximate and may be adjusted on site. All renderings are conceptual only, refer to written contract for actual specifications.

Josh Prine and Stephanie
1045 E King Street
Franklin, IN

Midwest
Remodeling

DRAWINGS PROVIDED BY:
Karen Shreves
karen@midwest-remodeling.com
765-716-0411

DATE:

11/19/2024

SCALE:

SHEET:

Steph's Kitchen



Josh Prine and Stephanie
1045 E King Street
Franklin, IN


**Midwest
Remodeling**

DRAWINGS PROVIDED BY:
Karen Shreves
karen@midwest-remodeling.com
765-776-0411

DATE:

11/19/2024

SCALE:


SHEET:

Accepted by: _____

Date: _____

All measurements are approximate and may be adjusted on site. All renderings are conceptual only, refer to written contract for actual specifications.

FOUNDATION

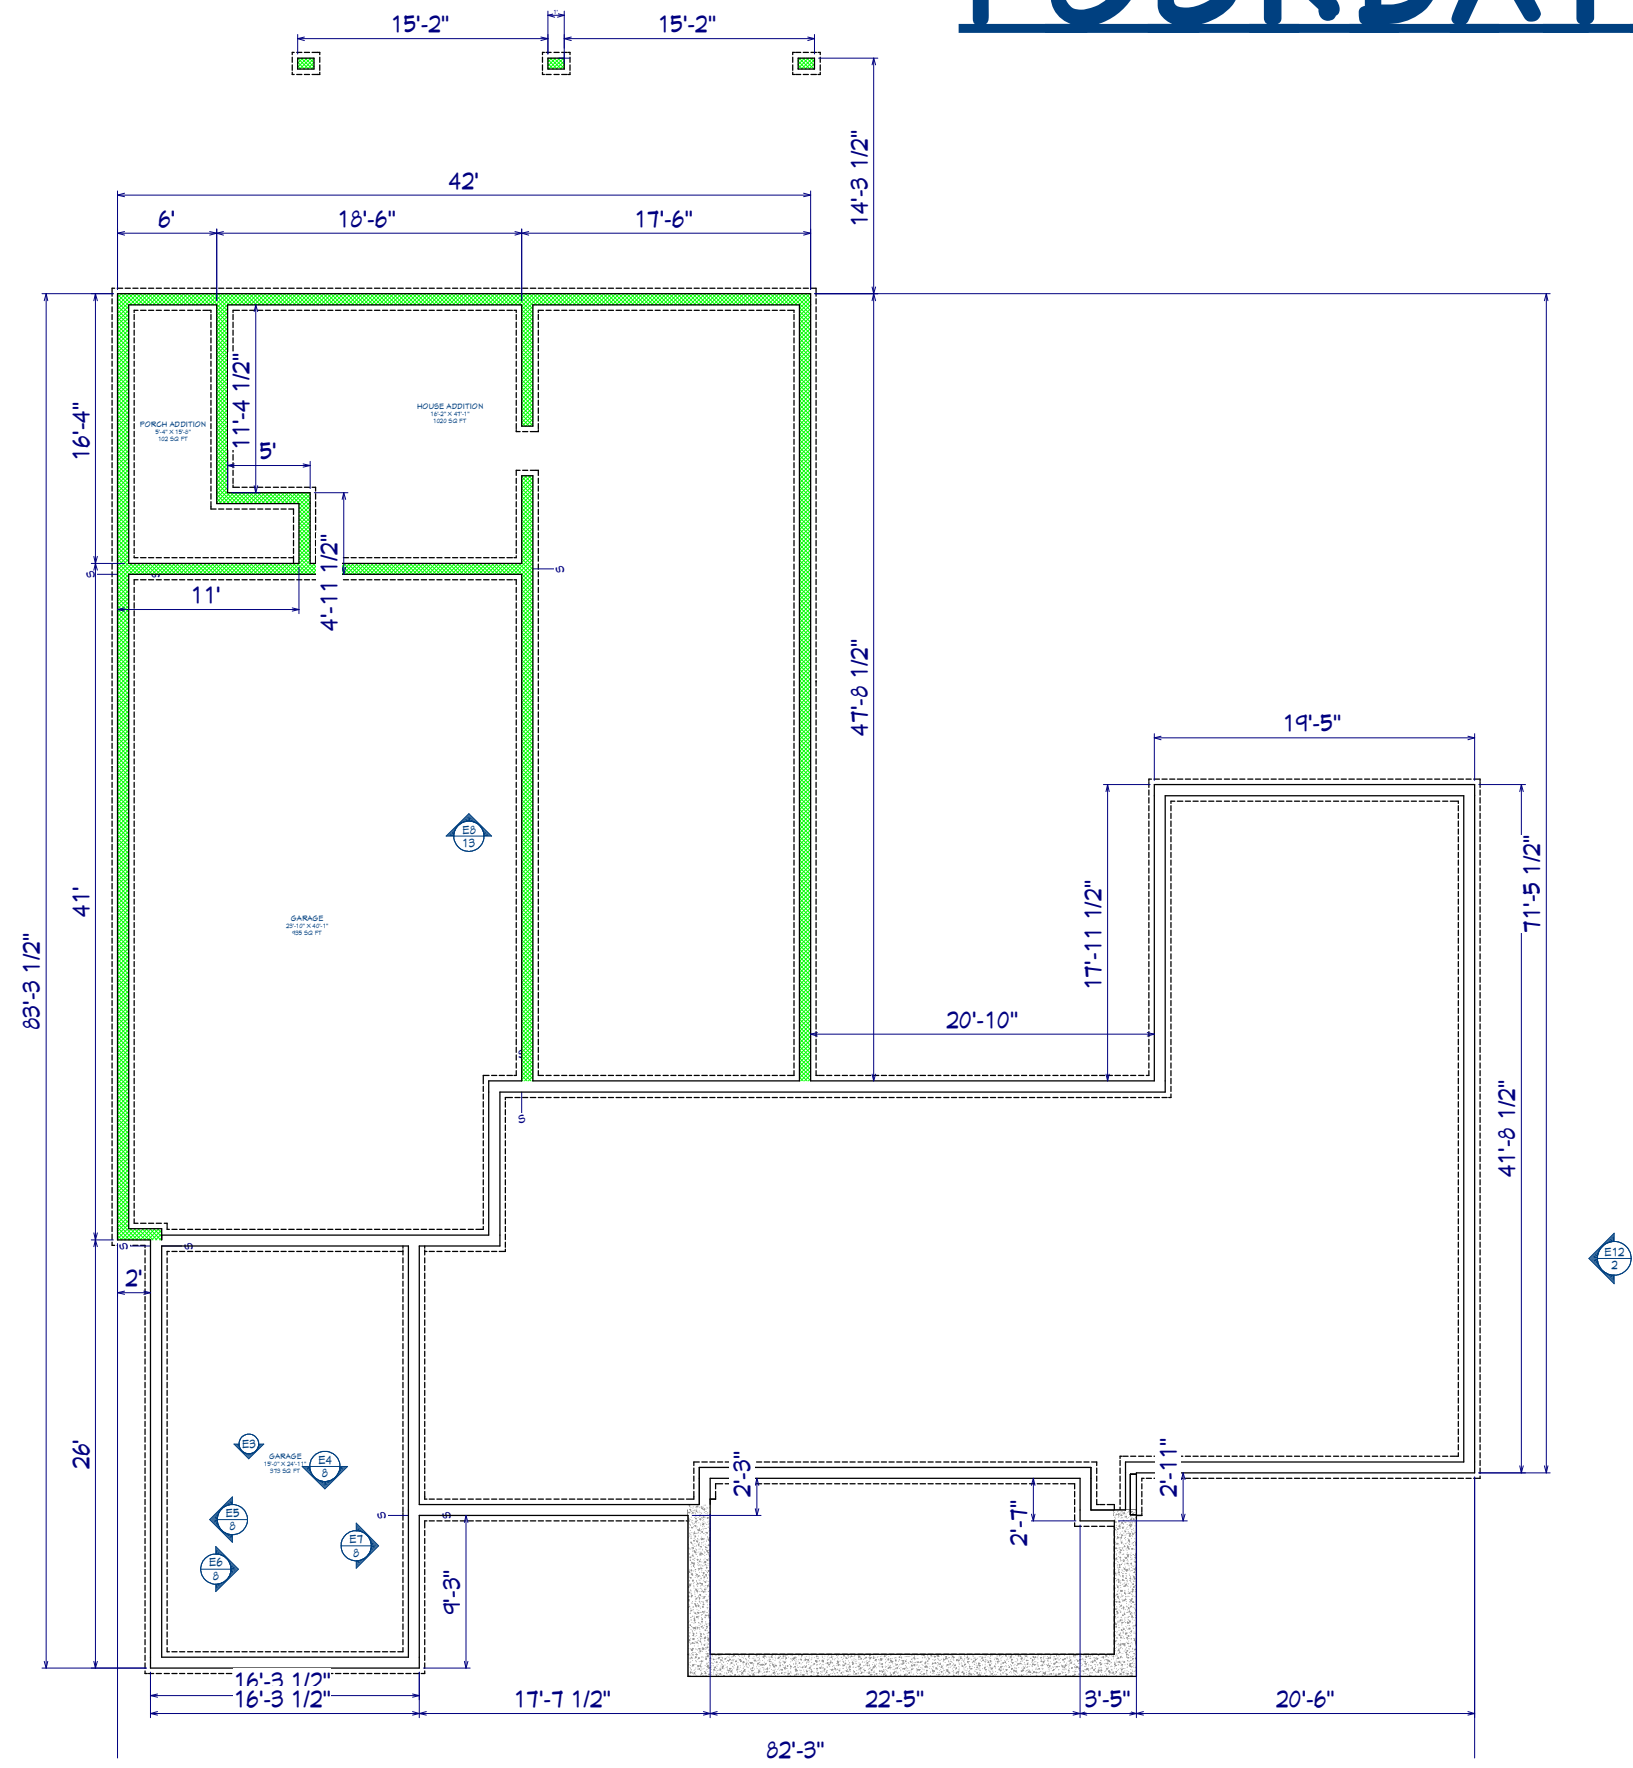

Accepted by: _____

Date: _____

All measurements are approximate and may be adjusted on site. All renderings are conceptual only, refer to written contract for actual specifications.

Josh Prine and Stephanie
1045 E King Street
Franklin, IN

Midwest
Remodeling

DRAWINGS PROVIDED BY:
Karen Shreves
karen@midwest-remodeling.com
765-776-0411


DATE:

11/19/2024

SCALE:

SHEET:

ELECTRICAL

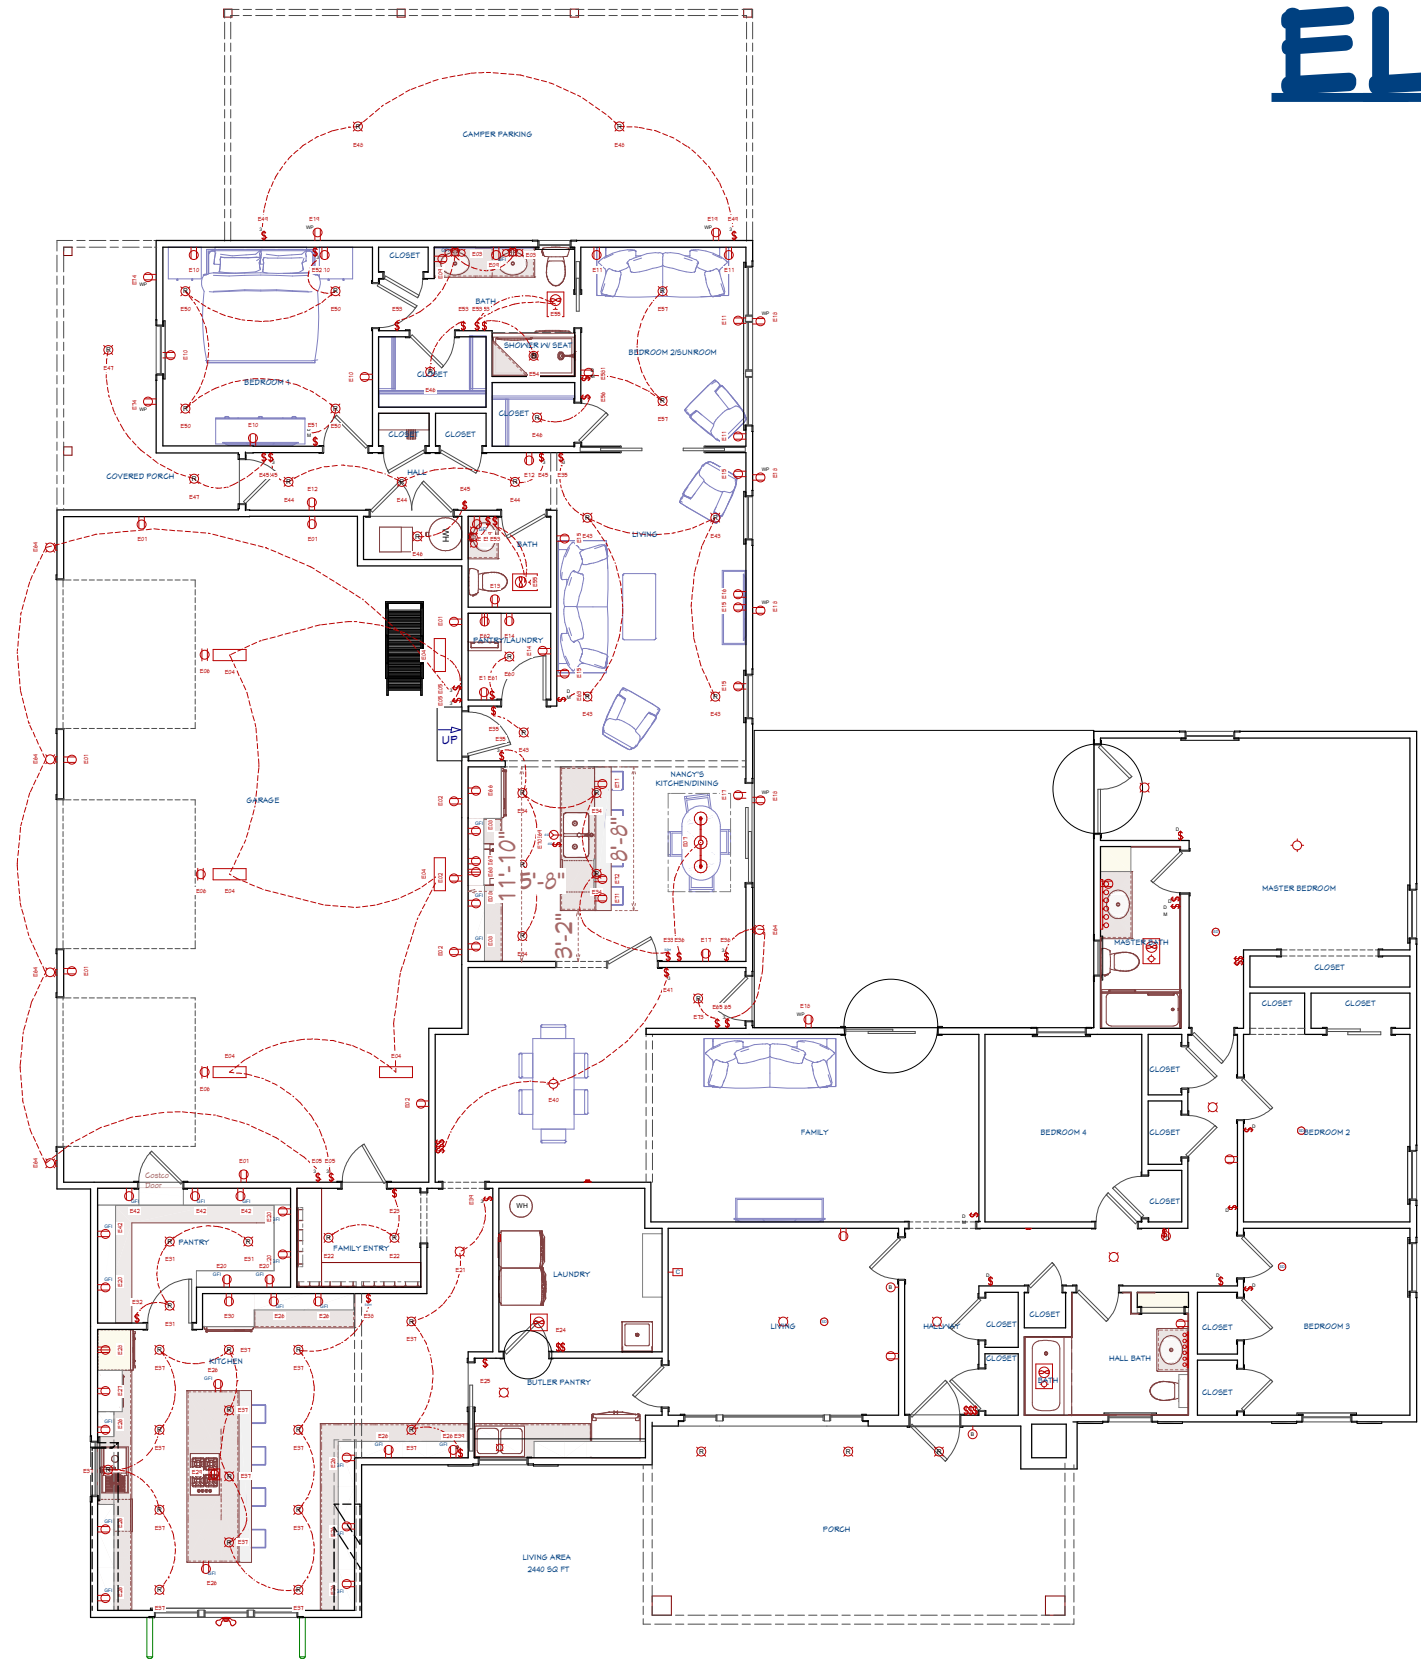

ELECTRICAL SCHEDULE					
LABEL	QTY	ROOM NAME	REF HEIGHT	DESCRIPTION	COMMENTS
E01	6	GARAGE	11 1/2"	DUPLEX-NEW	
E02	4	GARAGE	48"	DUPLEX-NEW	
E03	2	BATH	84"	VANITY LIGHT 3	EXISTING ELECTRICAL
E04	6	GARAGE	0"	CLOSET LED TUBE LIGHT	
E05	4	GARAGE	48"	NEW SWITCH	
E06	3	GARAGE	0"	DUPLEX CEILING RECEPTACLE	
E07	1	NANCY'S KITCHEN/DINING	0"	NEW FIXTURE	
E08	3	NANCY'S KITCHEN/DINING	11 1/2"	GFI	
E09	3	BATH	11 1/2"	GFI	
E10	5	BEDROOM 1	11 1/2"	DUPLEX-NEW	
E11	5	BEDROOM 2/SUNROOM	11 1/2"	DUPLEX-NEW	
E12	2	HALL	11 1/2"	DUPLEX-NEW	
E13	1	BATH	11 1/2"	DUPLEX-NEW	
E14	3	PANTRY/LAUNDRY	11 1/2"	DUPLEX-NEW	
E15	5	LIVING	11 1/2"	DUPLEX-NEW	
E16	1	LIVING	60"	DUPLEX-NEW	
E17	2	NANCY'S KITCHEN/DINING	11 1/2"	DUPLEX-NEW	
E18	5		11 1/2"	DUPLEX (WEATHERPROOF)	
E19	2	CAMPER PARKING	11 1/2"	DUPLEX (WEATHERPROOF)	
E20	5	PANTRY	11 1/2"	GFI	
E21	1	KITCHEN	0"	CONTEMPORARY FLUSH	MOVE EXISTING ELECTRICAL AS NEEDED
E22	2	FAMILY ENTRY	0"	DOWN LIGHT-NEW	
E23	1	FAMILY ENTRY	48"	NEW SWITCH	
E24	1	LAUNDRY	52"	2 GANG SWITCH	MOVE EXISTING ELECTRICAL SWITCHES
E25	1	BUTLER PANTRY	43"	SWITCH (DECORATOR)	MOVE EXISTING ELECTRICAL SWITCH AS NEEDED
E26	12	KITCHEN	11 1/2"	GFI	
E27	1	KITCHEN	60"	DUPLEX-NEW	MICROWAVE
E28	1	KITCHEN	11 1/2"	220V	DOUBLE OVEN
E29	1	KITCHEN	0"	220V FLOOR RECEPTACLE	COOKTOP
E30	1	KITCHEN	11 1/2"	DUPLEX-NEW	REFRIGERATOR
E31	3	PANTRY	0"	DOWN LIGHT-NEW	
E32	1	PANTRY	48"	NEW SWITCH	
E33	1	NANCY'S KITCHEN/DINING	48"	3-WAY DIMMER	
E34	5	NANCY'S KITCHEN/DINING	0"	DOWN LIGHT-NEW	
E35	3	LIVING	48"	NEW SWITCH	
E36	2	NANCY'S KITCHEN/DINING	48"	NEW SWITCH	
E37	15	KITCHEN	0"	DOWN LIGHT-NEW	
E38	1	KITCHEN	48"	3-WAY DIMMER	
E39	2	KITCHEN	48"	NEW SWITCH	
E40	1	DINING	0"	WAREHOUSE PENDANT	MOVE EXISTING ELECTRICAL FIXTURE TO CENTER
E41	1	DINING	48"	NEW SWITCH FOR 3-WAY	
E42	4	PANTRY	42"	GFI	
E43	5	LIVING	0"	DOWN LIGHT-NEW	
E44	3	HALL	0"	DOWN LIGHT-NEW	
E45	4	HALL	48"	NEW SWITCH	
E46	3	CLOSET	0"	DOWN LIGHT-NEW	
E47	2	COVERED PORCH	0"	DOWN LIGHT-NEW	
E48	2	CAMPER PARKING	0"	DOWN LIGHT-NEW	
E49	2	CAMPER PARKING	48"	THREE WAY	
E50	4	BEDROOM 1	0"	DOWN LIGHT-NEW	
E51	1	BEDROOM 1	11 1/2"	DIMMER SWITCH SLIDE	
E52	1	BEDROOM 1	48"	NEW SWITCH	
E53	6	BATH	48"	NEW SWITCH	
E54	1	SHOWER W/ SEAT	0"	DOWN LIGHT-NEW	
E55	2	BATH	0"	BATH FAN/LIGHT	
E56	1	BEDROOM 2/SUNROOM	48"	NEW SWITCH	
E57	2	BEDROOM 2/SUNROOM	0"	DOWN LIGHT-NEW	
E58	1	BEDROOM 2/SUNROOM	11 1/2"	DIMMER SWITCH SLIDE	
E59	1	BATH	84"	VANITY LIGHT 3	
E60	1	PANTRY/LAUNDRY	0"	DOWN LIGHT-NEW	
E61	1	PANTRY/LAUNDRY	48"	NEW SWITCH	
E62	1	PANTRY/LAUNDRY	11 1/2"	220V	DRYER
E63	1	LIVING	11 1/2"	DIMMER SWITCH SLIDE	
E64	5		72"	CAGED LANTERN SCONCE	
E65	2	DINING	48"	NEW SWITCH	
E66	1	NANCY'S KITCHEN/DINING	11 1/2"	DUPLEX-NEW	REFRIGERATOR
E67	1	NANCY'S KITCHEN/DINING	60"	DUPLEX-NEW	MICROWAVE ABOVE RANGE
E68	1	NANCY'S KITCHEN/DINING	11 1/2"	220V	RANGE
E69	1	NANCY'S KITCHEN/DINING	11 1/2"	GARBAGE DISPOSAL RECEPTACLE	
E70	1	NANCY'S KITCHEN/DINING	33 1/2"	GARBAGE DISPOSAL SWITCH	
E71	2	NANCY'S KITCHEN/DINING	32"	DUPLEX	ISLAND OUTLETS
E72	1	NANCY'S KITCHEN/DINING	32"	DUPLEX	DISHWASHER
E73	1	DINING	0"	DOWN LIGHT-NEW	
E74	2	COVERED PORCH	11 1/2"	DUPLEX (WEATHERPROOF)	

Josh Prine and Stephanie
1045 E King Street
Franklin, IN

Midwest
Remodeling

DRAWINGS PROVIDED BY:
Karen Shreves
Karen@Midwest-Remodeling.com
765-776-5411

DATE:

11/19/2024

SCALE:


SHEET:

Accepted by: _____

Date: _____

All measurements are approximate and may be adjusted on site. All renderings are conceptual only, refer to written contract for actual specifications.

Camper Space

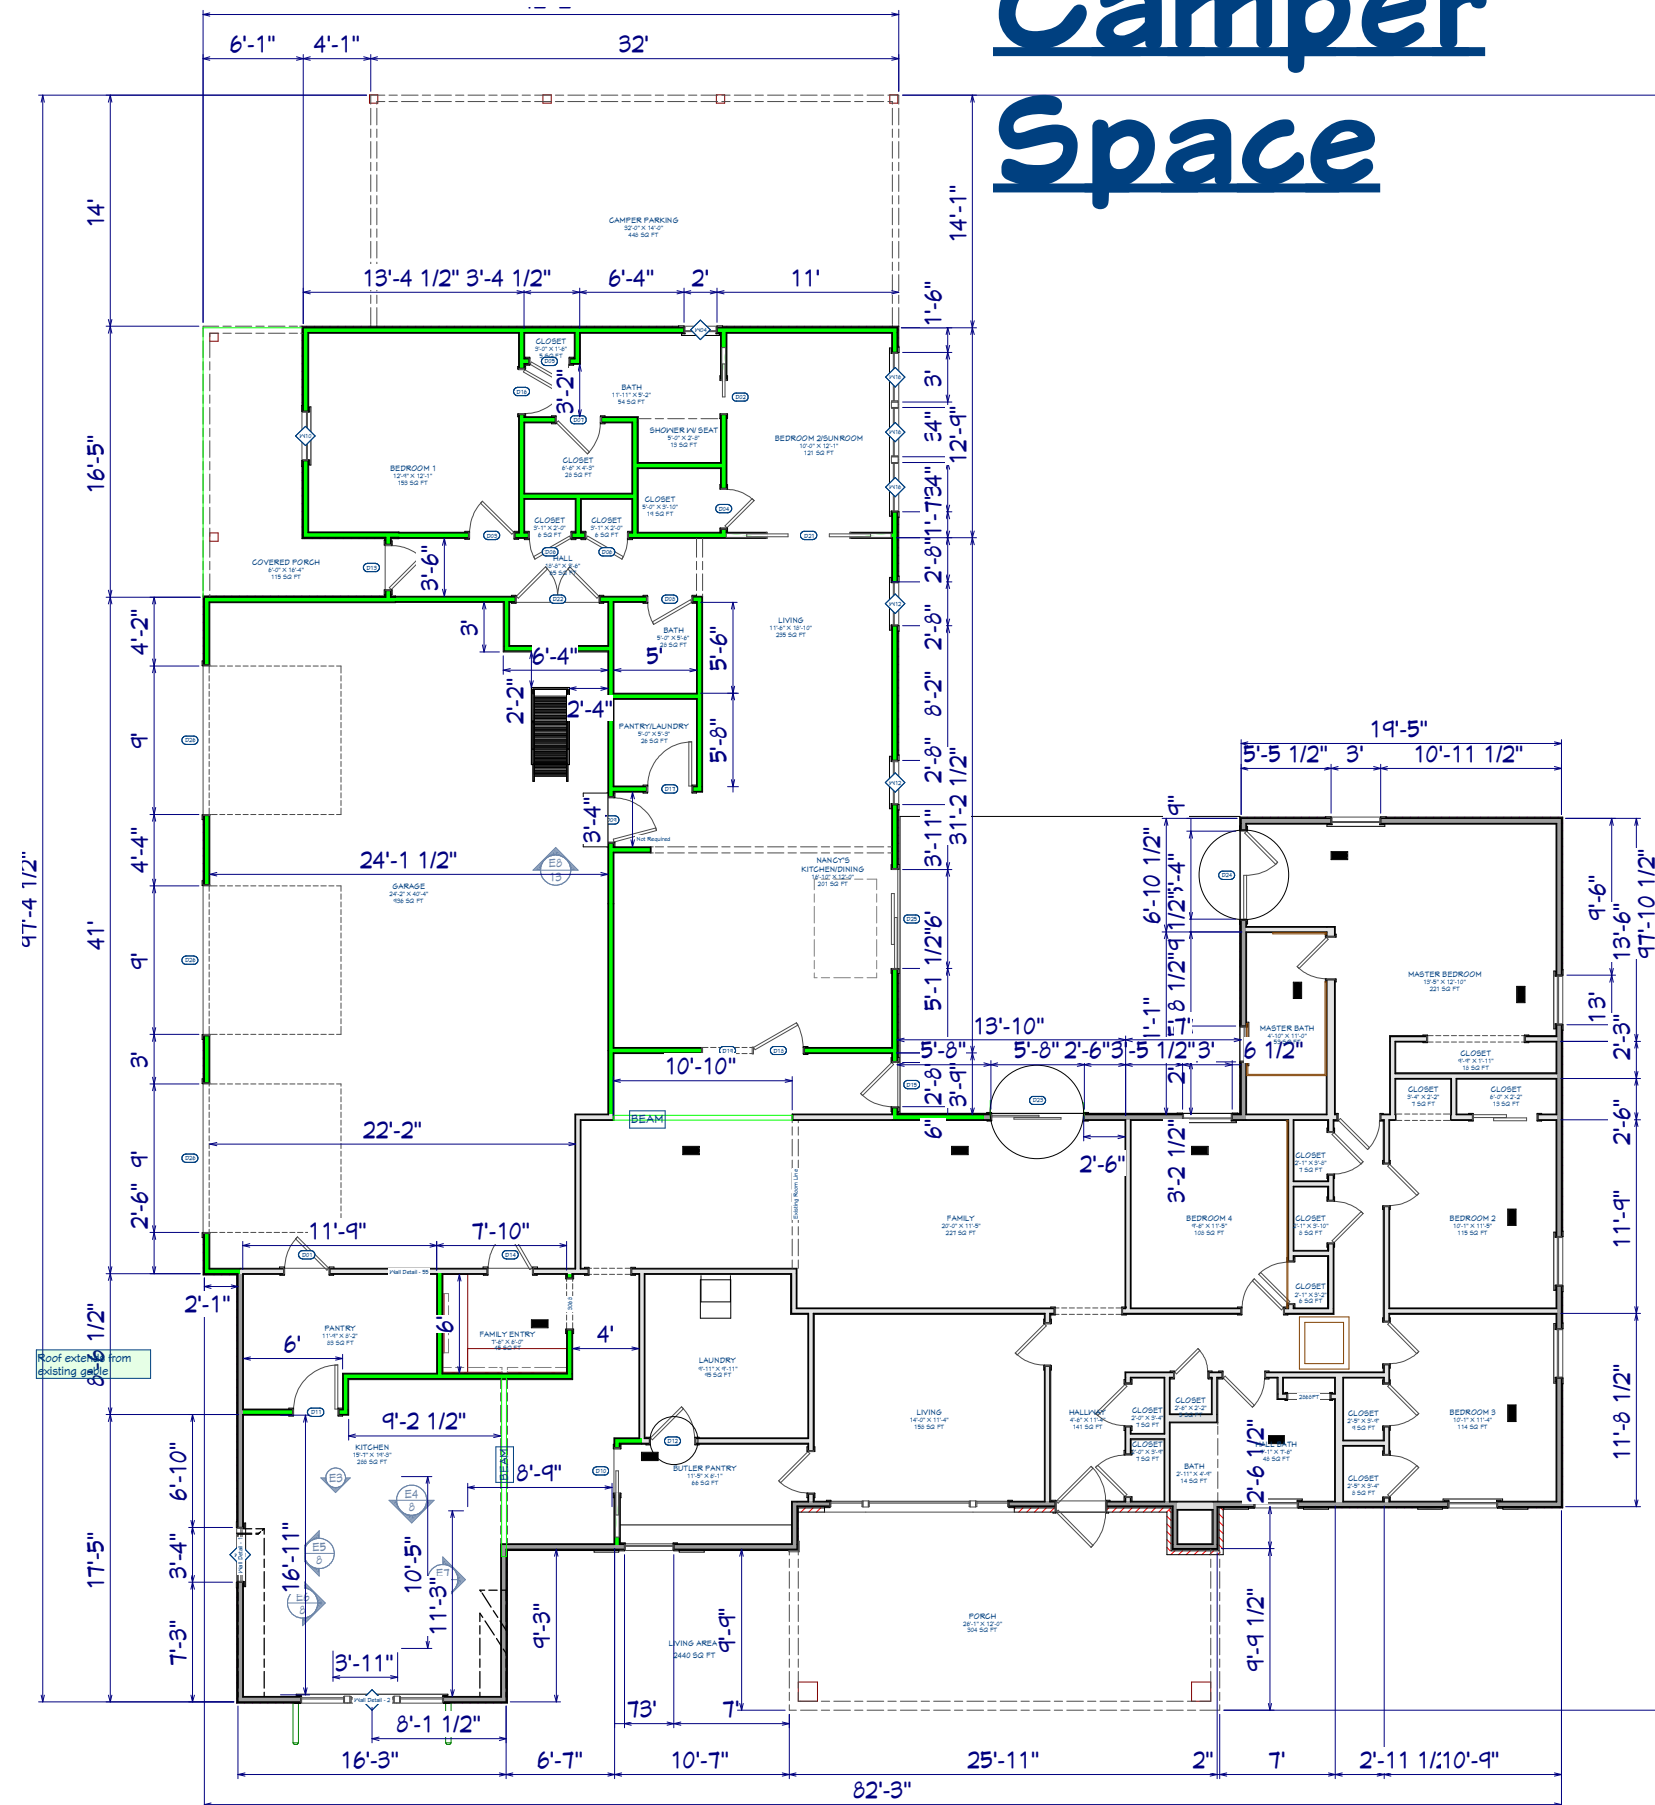

Josh Prine and Stephanie
1045 E King Street
Franklin, IN



Midwest Remodel

DRAWINGS PROVIDED BY:
Karen Shreves
karens@Midwest-Remodeling.com
765-778-8471

DATE:

11/19/2024

SCALE:




SHEET:

Accepted by: _____

Date: _____

All measurements are approximate and may be adjusted on site. All renderings are conceptual only, refer to written contract for actual specifications.

Attic Storage

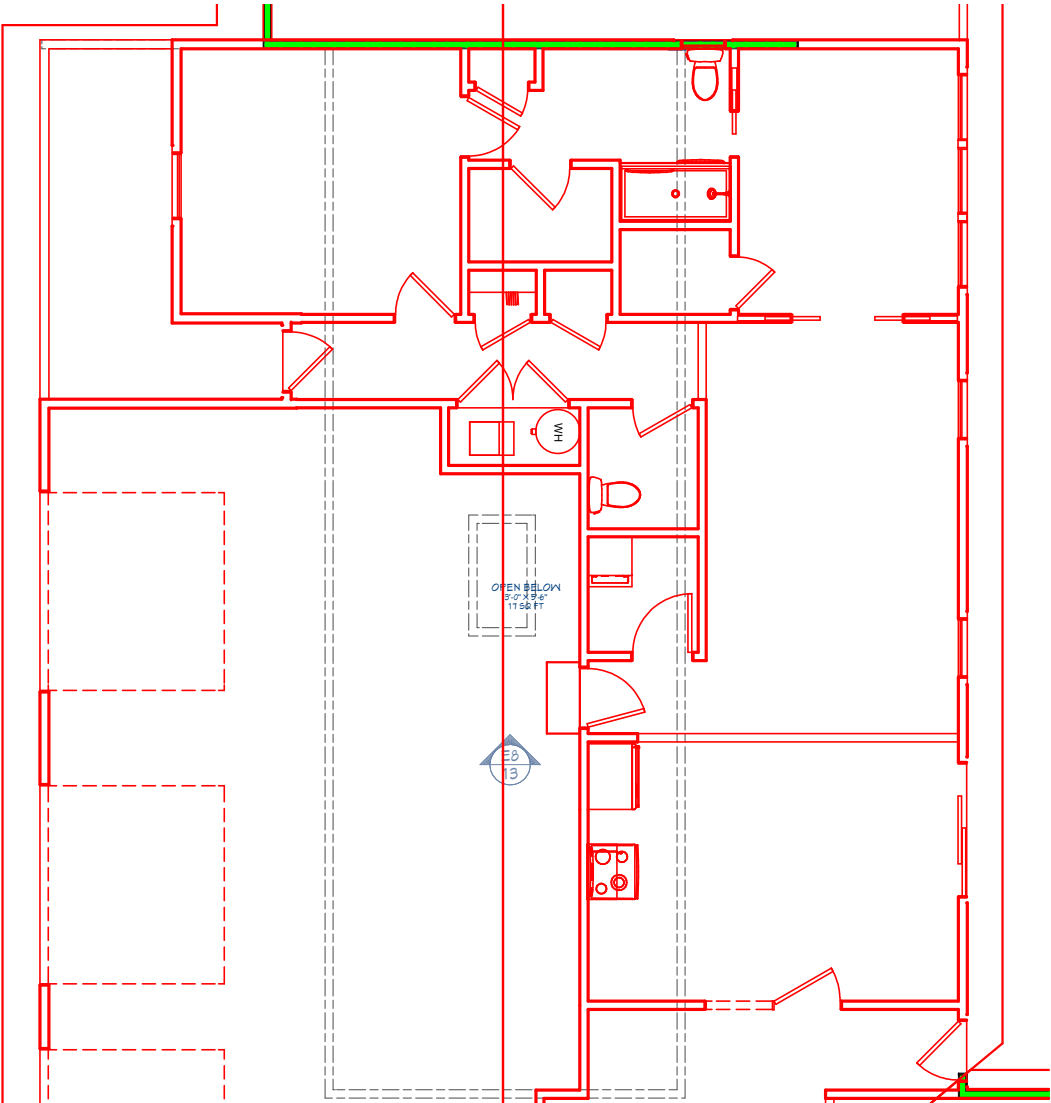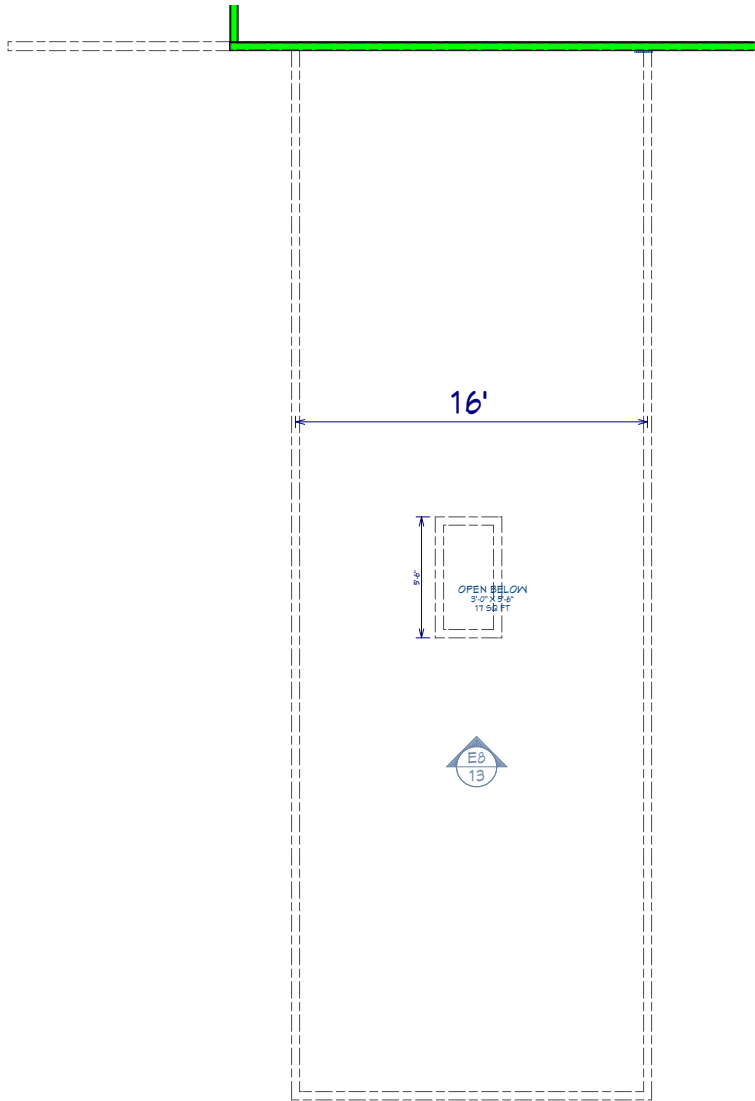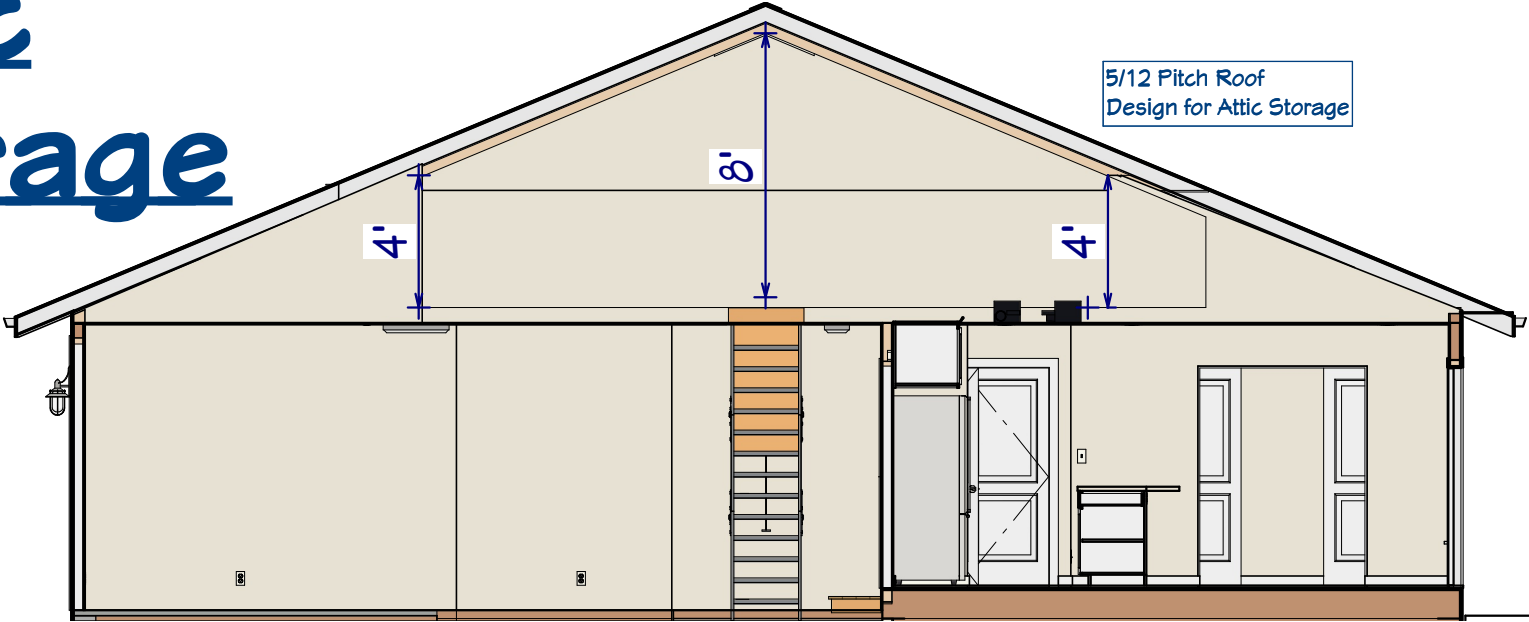

All measurements are approximate and may be adjusted on site. All renderings are conceptual only, refer to written contract for actual specifications.

Josh Prine and Stephanie
1045 E King Street
Franklin, IN


**Midwest
Remodeling**

DRAWINGS PROVIDED BY:
Karen Shreves
karen@Midwest-Remodeling.com
765-776-0411


DATE:
11/19/2024

SCALE:

SHEET:

Accepted by: _____ Date: _____

BEFORE

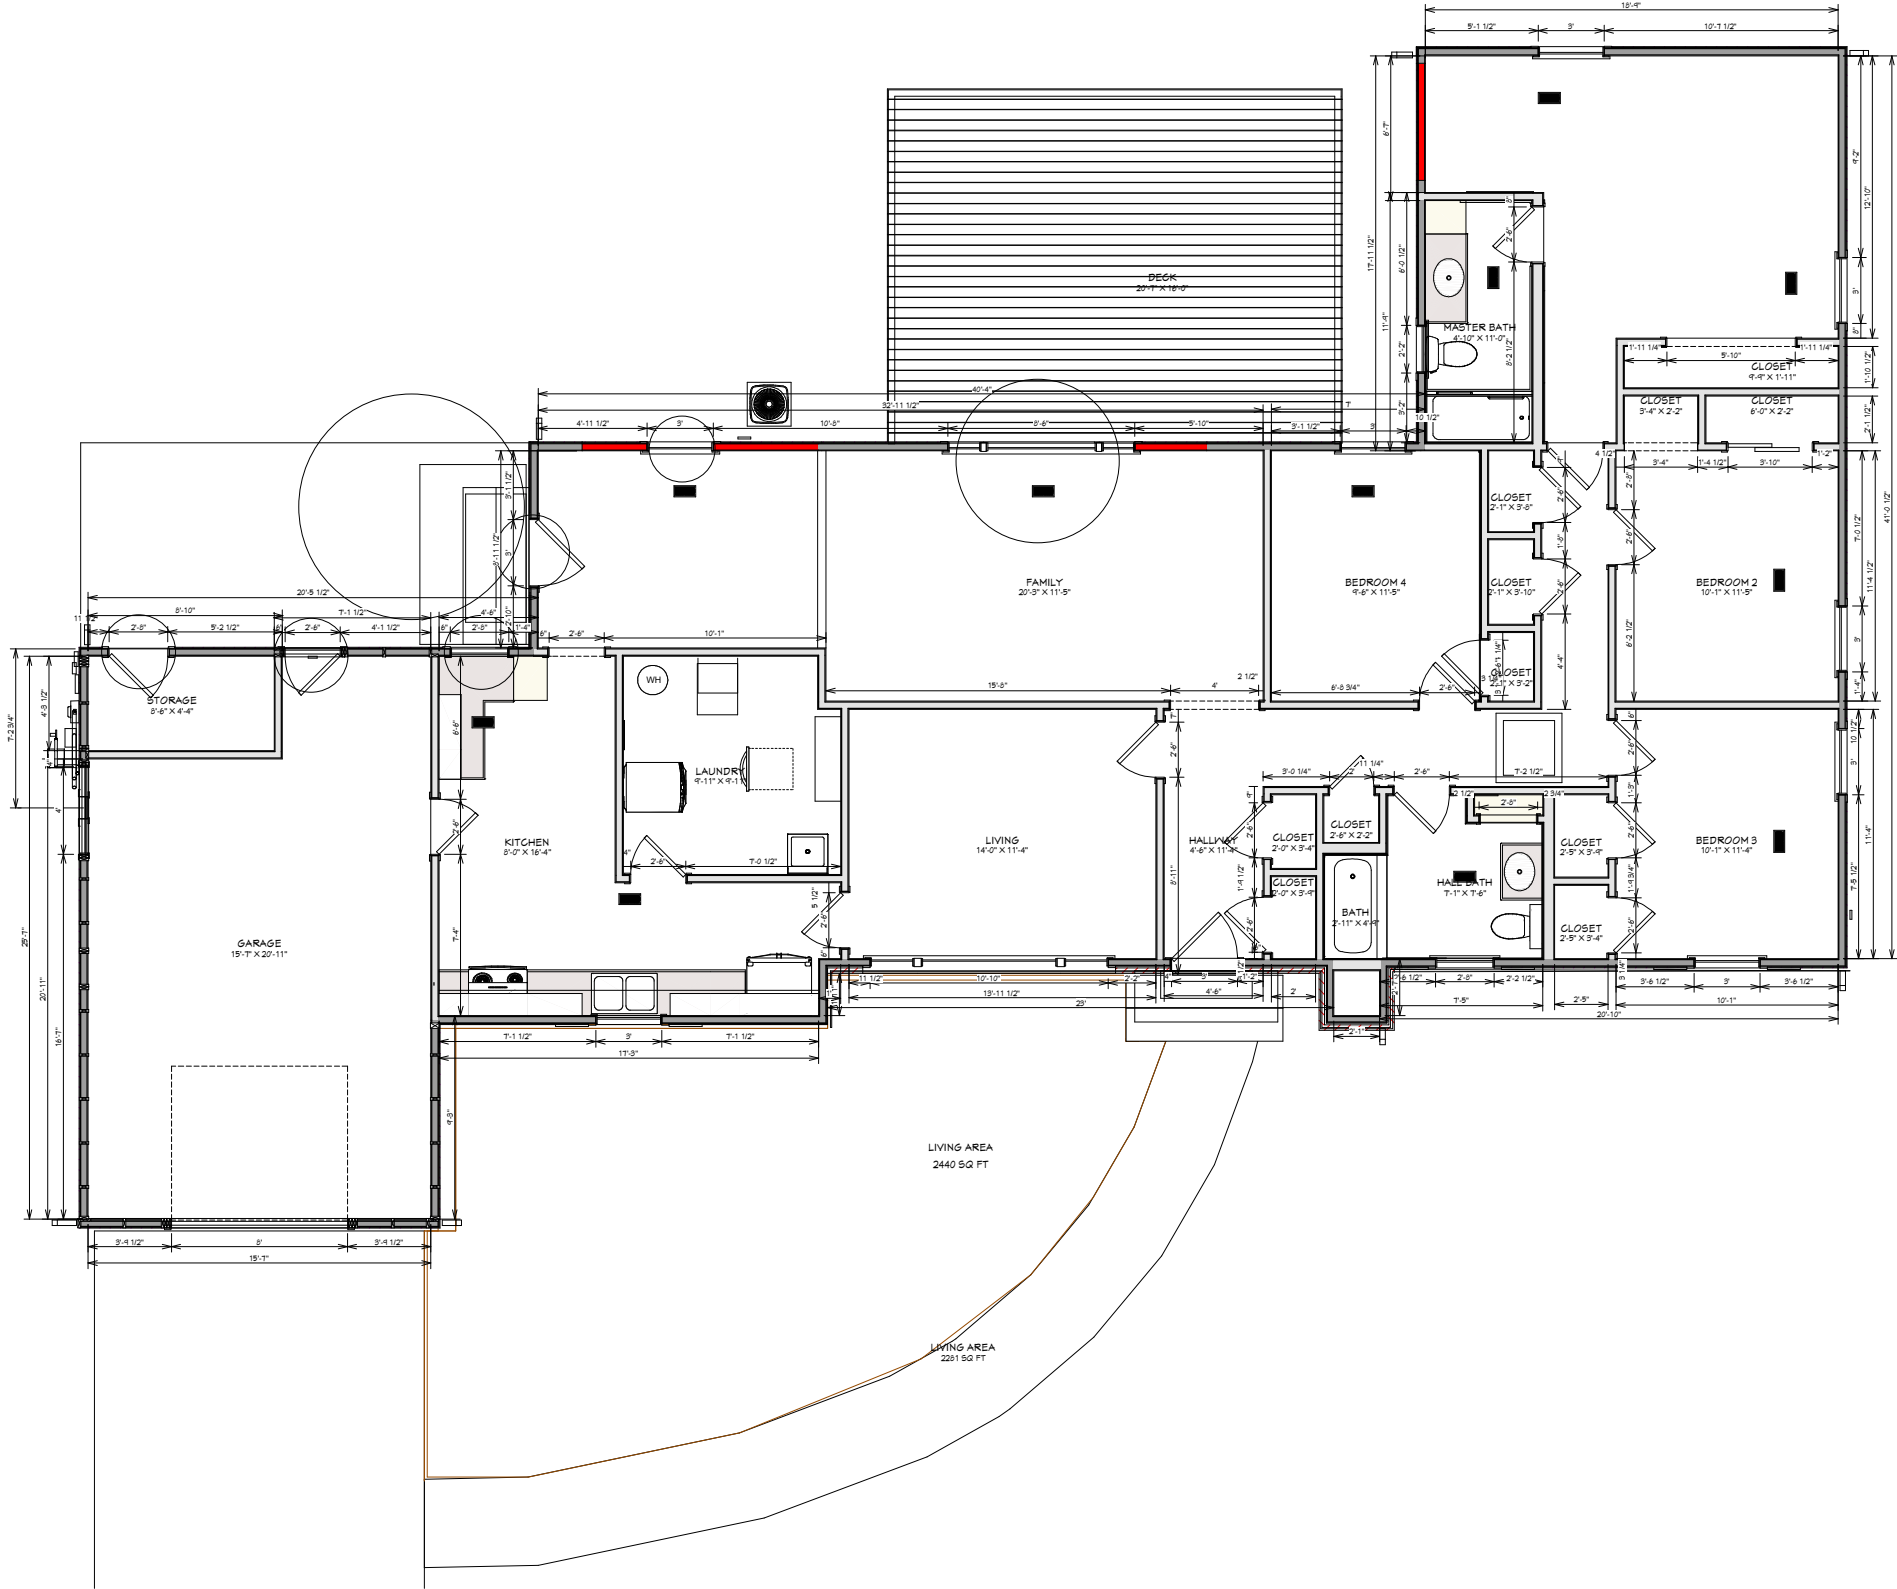

1st Floor

All measurements are approximate and may be adjusted on site. All renderings are conceptual only, refer to written contract for actual specifications.

Josh Prine and Stephanie
1045 E King Street
Franklin, IN



DRAWINGS PROVIDED BY:
Karen Shreeves
karen@midwest-remodeling.com
765-776-0411

DATE:
11/19/2024

SCALE:

SHEET:

Accepted by: _____ Date: _____