


|                            |                |
|----------------------------|----------------|
| INDIANA AMERICAN WATER CO. | 317-881-0270   |
| VECTREN ENERGY DELIVERY    | 1-800-227-1376 |
| EMBARQ (CENTURY LINK)      | 1-800-382-5544 |
| DUKE ENERGY                | 811            |
| FRANKLIN DPW               | 317-736-3640   |
| COMCAST                    | 317-535-4198   |


NOTE: CONTRACTOR TO REQUEST  
"CONSTRUCTION SET" PRIOR TO  
START OF CONSTRUCTION.

1. TITLE SHEET
2. EXISTING CONDITIONS SURVEY
3. PROPOSED SITE PLAN
4. LANDSCAPING AND EROSION CONTROL

Lot No. 2 in Industrial Drive Subdivision, Plat Cabinet "D" pages 447A & B, office of the Recorder of Johnson County, Indiana.

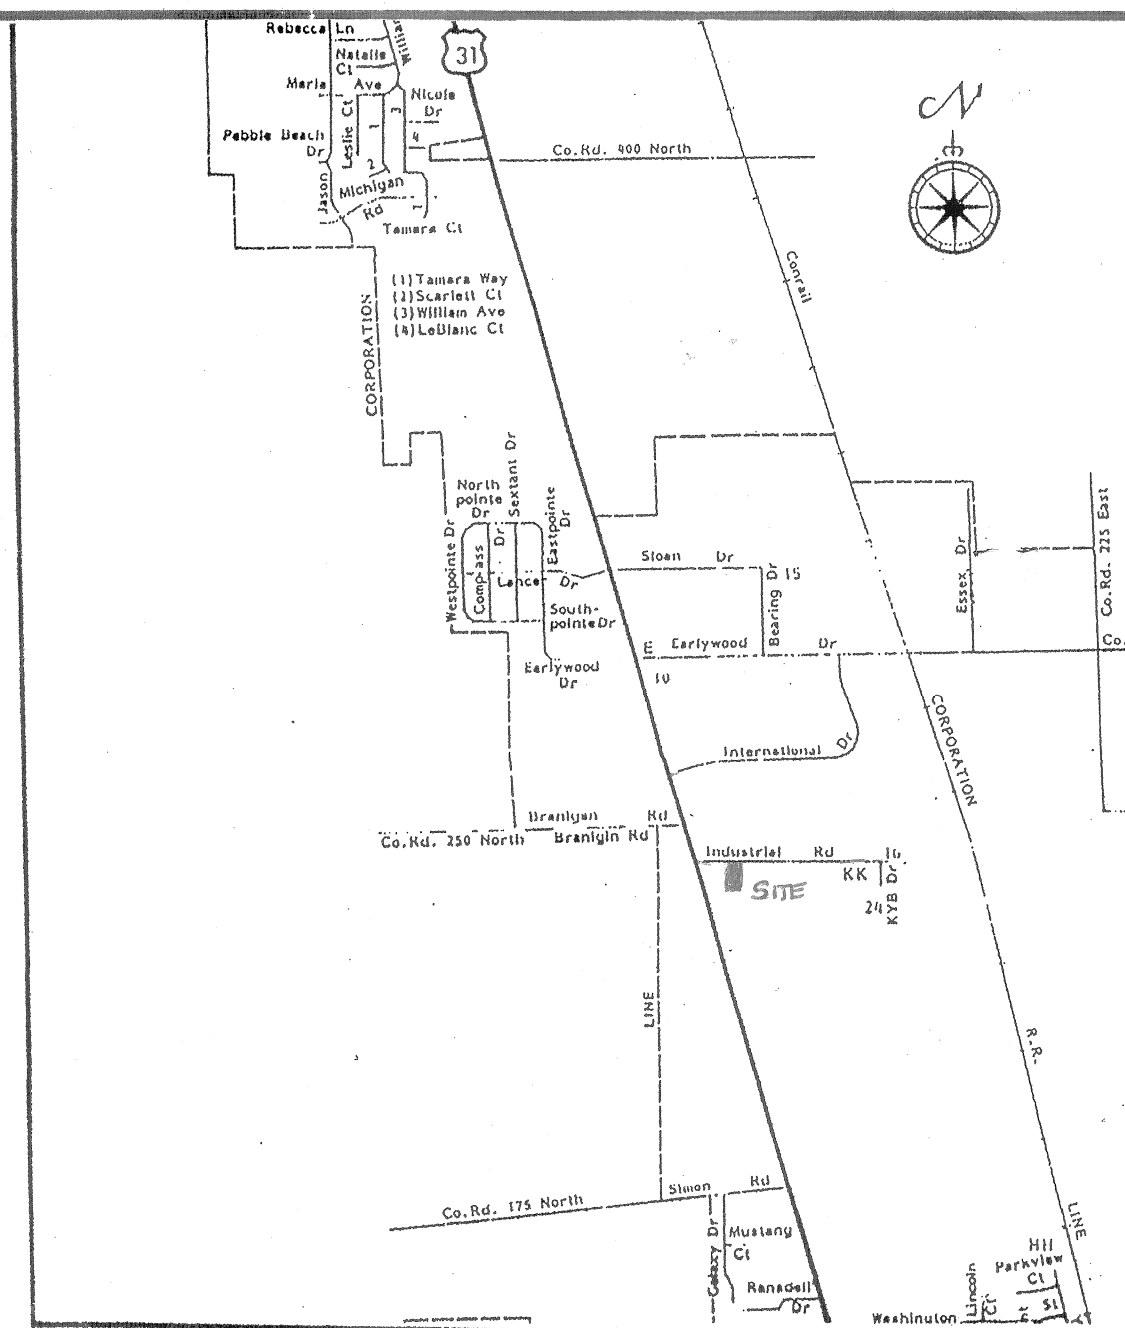

### LOCATION MAP

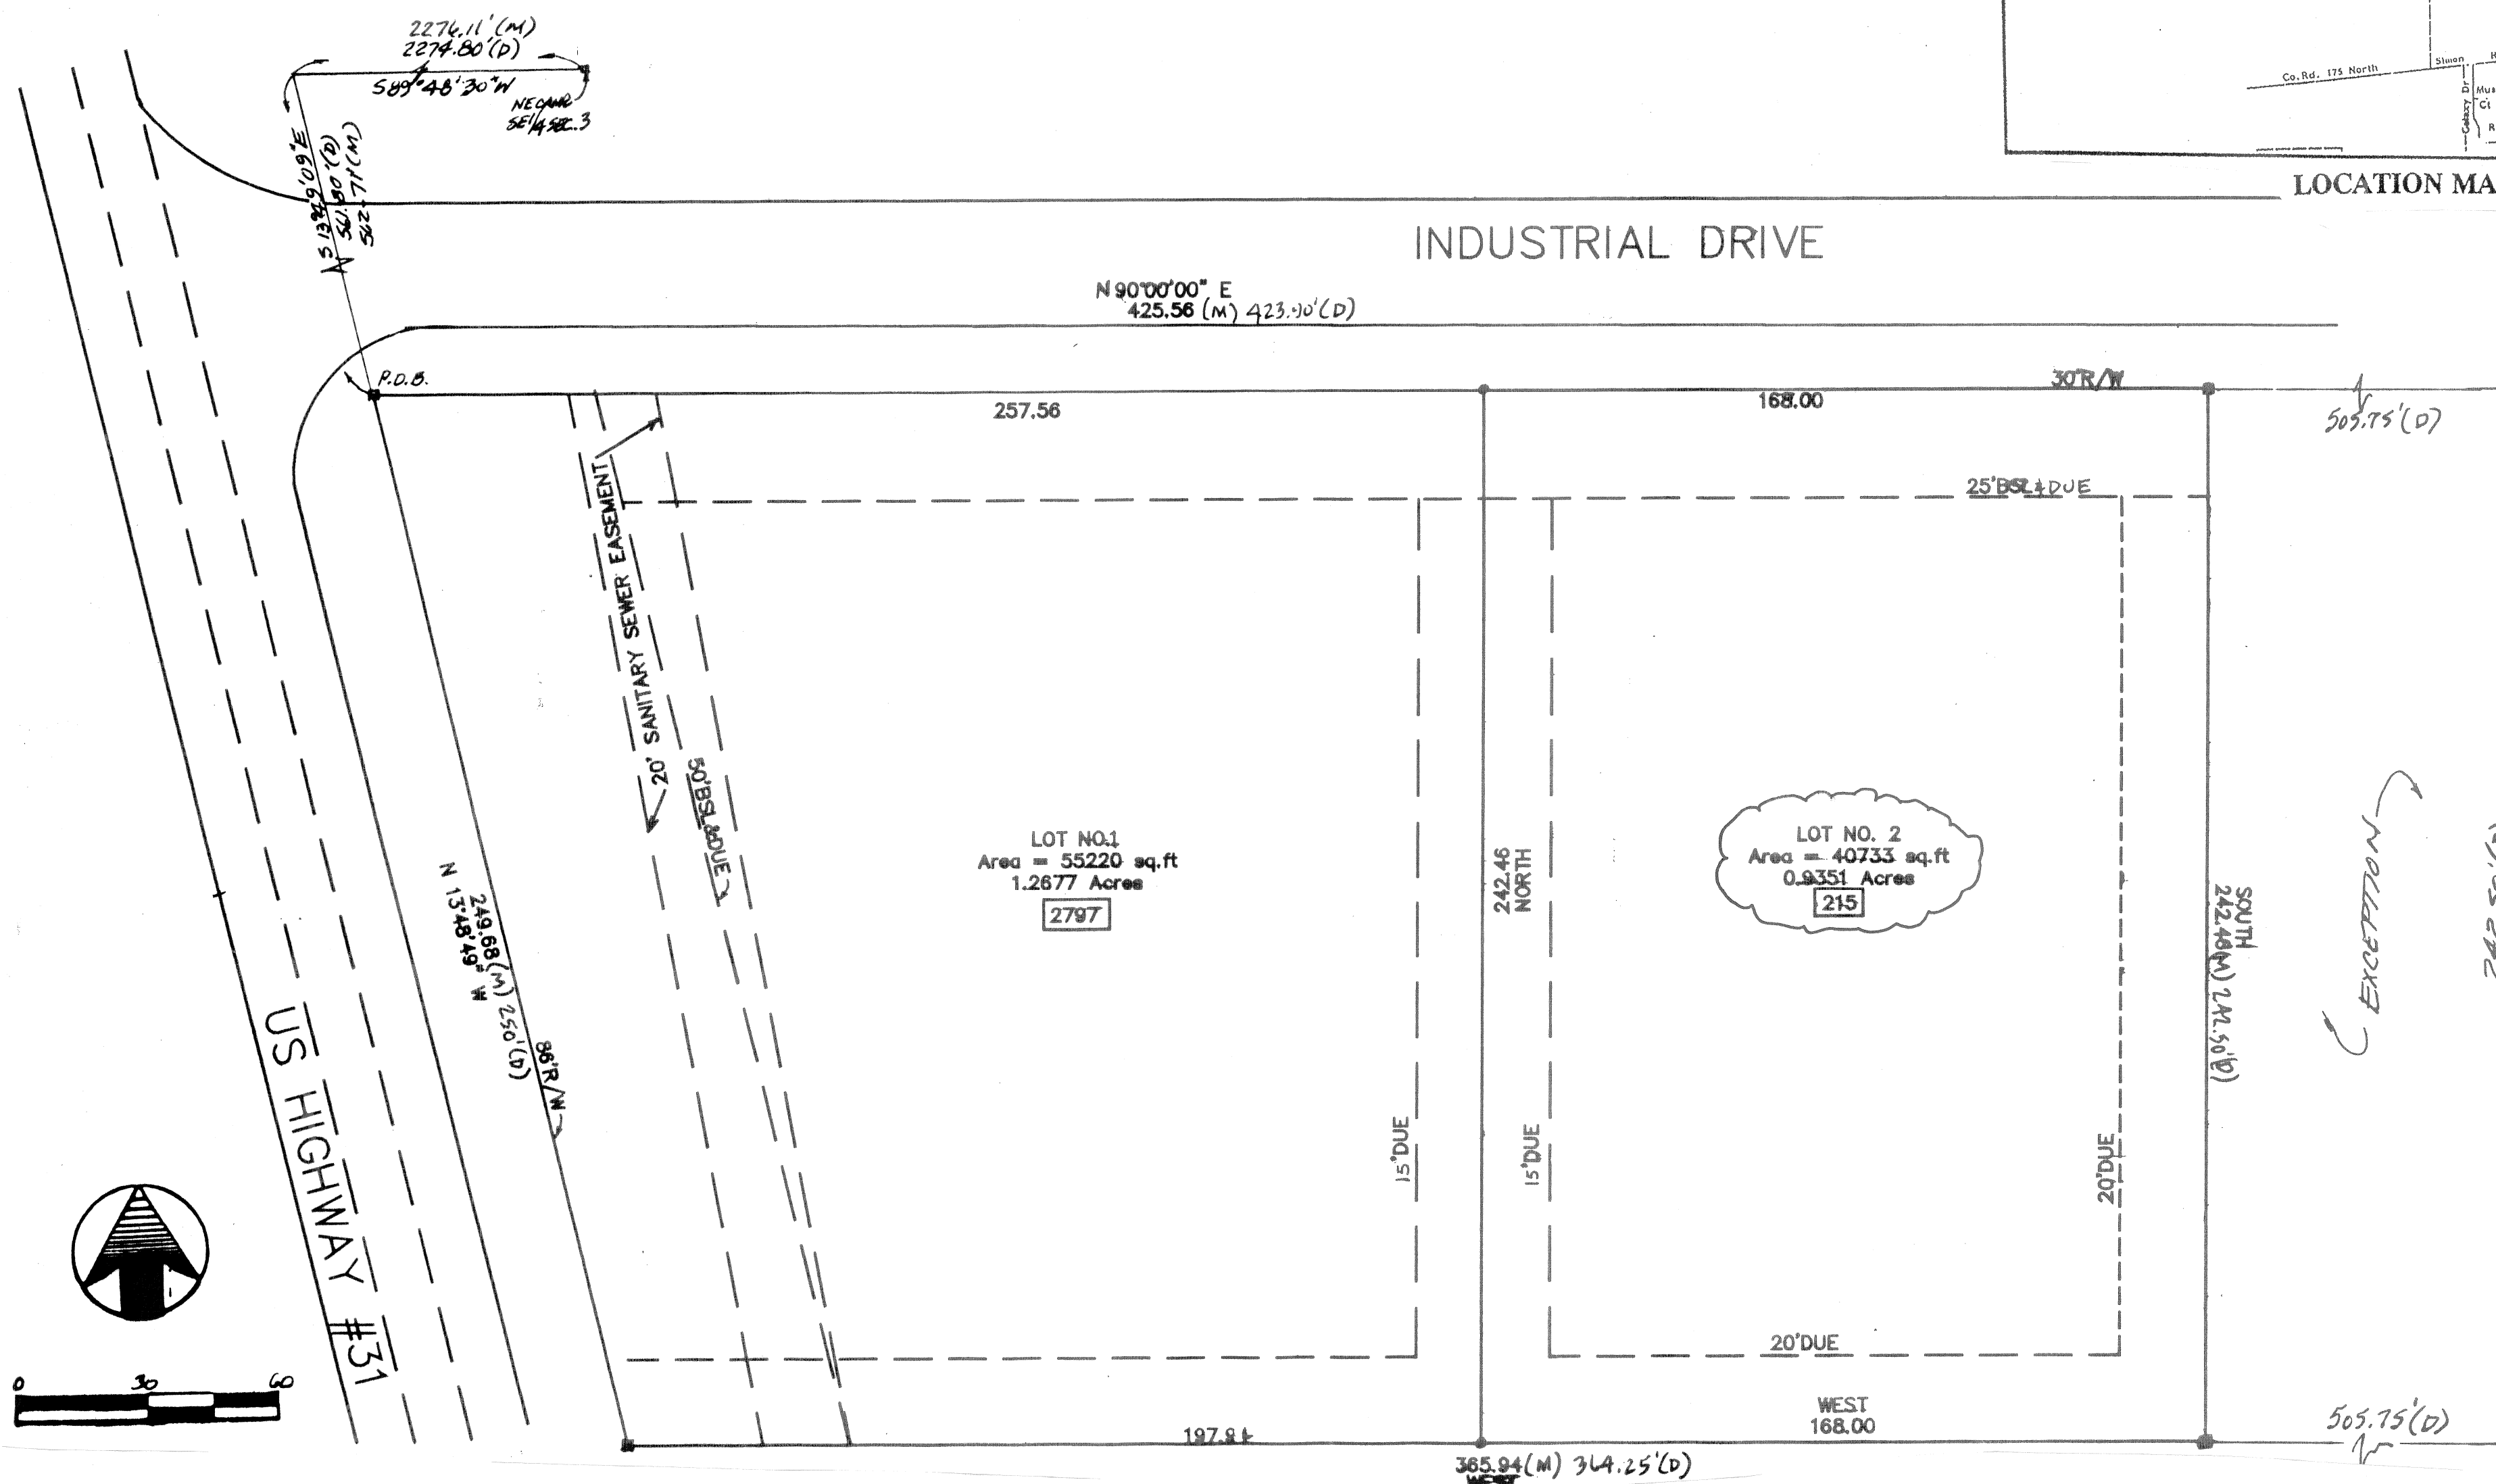

A circular professional engineer seal for Steven B. Williams. The outer ring contains the text "STEVEN B. WILLIAMS" at the top and "PROFESSIONAL ENGINEER" at the bottom. The inner circle contains the text "REGISTERED" at the top, "No. 17207" in the center, and "STATE OF INDIANA" at the bottom. The seal is surrounded by a decorative border.

DESIGNED:

**DRAWN:**

**CHECKED:**

TITLE SHEET  
2012 BUILDING AND PARKING LOT ADDITION  
JM STEVENS ENTERPRISES, LLC  
215 INDUSTRIAL DRIVE, FRANKLIN

Stephen B. Williams.

Engineering and Surveying  
 225 E. Erie Pl., Wash.  
 Me., 184 46' 18

Muskegon, Indiana 40104  
 017 660 7790 DE: 017 505 1065 384549

## REVISIONS

| DATE | REVISION |
|------|----------|
|      |          |
|      |          |

PROJ. NO: SW-451

SCALE: 1"=60'

DATE: 5-15-12


FILE NO:

SHT / OF 4


| REVISONS                                                                     |          |
|------------------------------------------------------------------------------|----------|
| DATE                                                                         | REVISION |
|                                                                              |          |
|                                                                              |          |
| PROJ. NO: 5W-451<br>SCALE: 1"=20'<br>DATE: 5-15-12<br>FILE NO:<br>SHT 2 OF 4 |          |





- DON'T  
DIG  
BLIND**

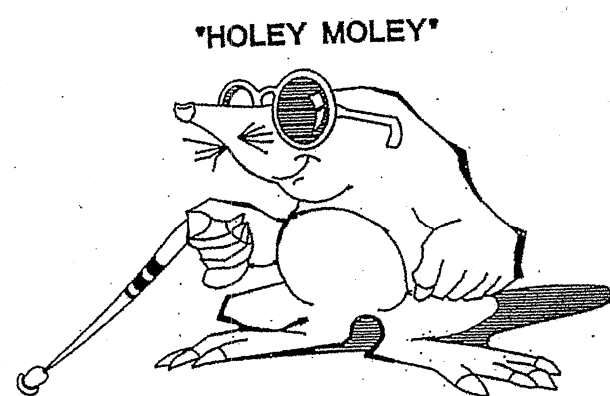

## 2-21" HDPE PIPES

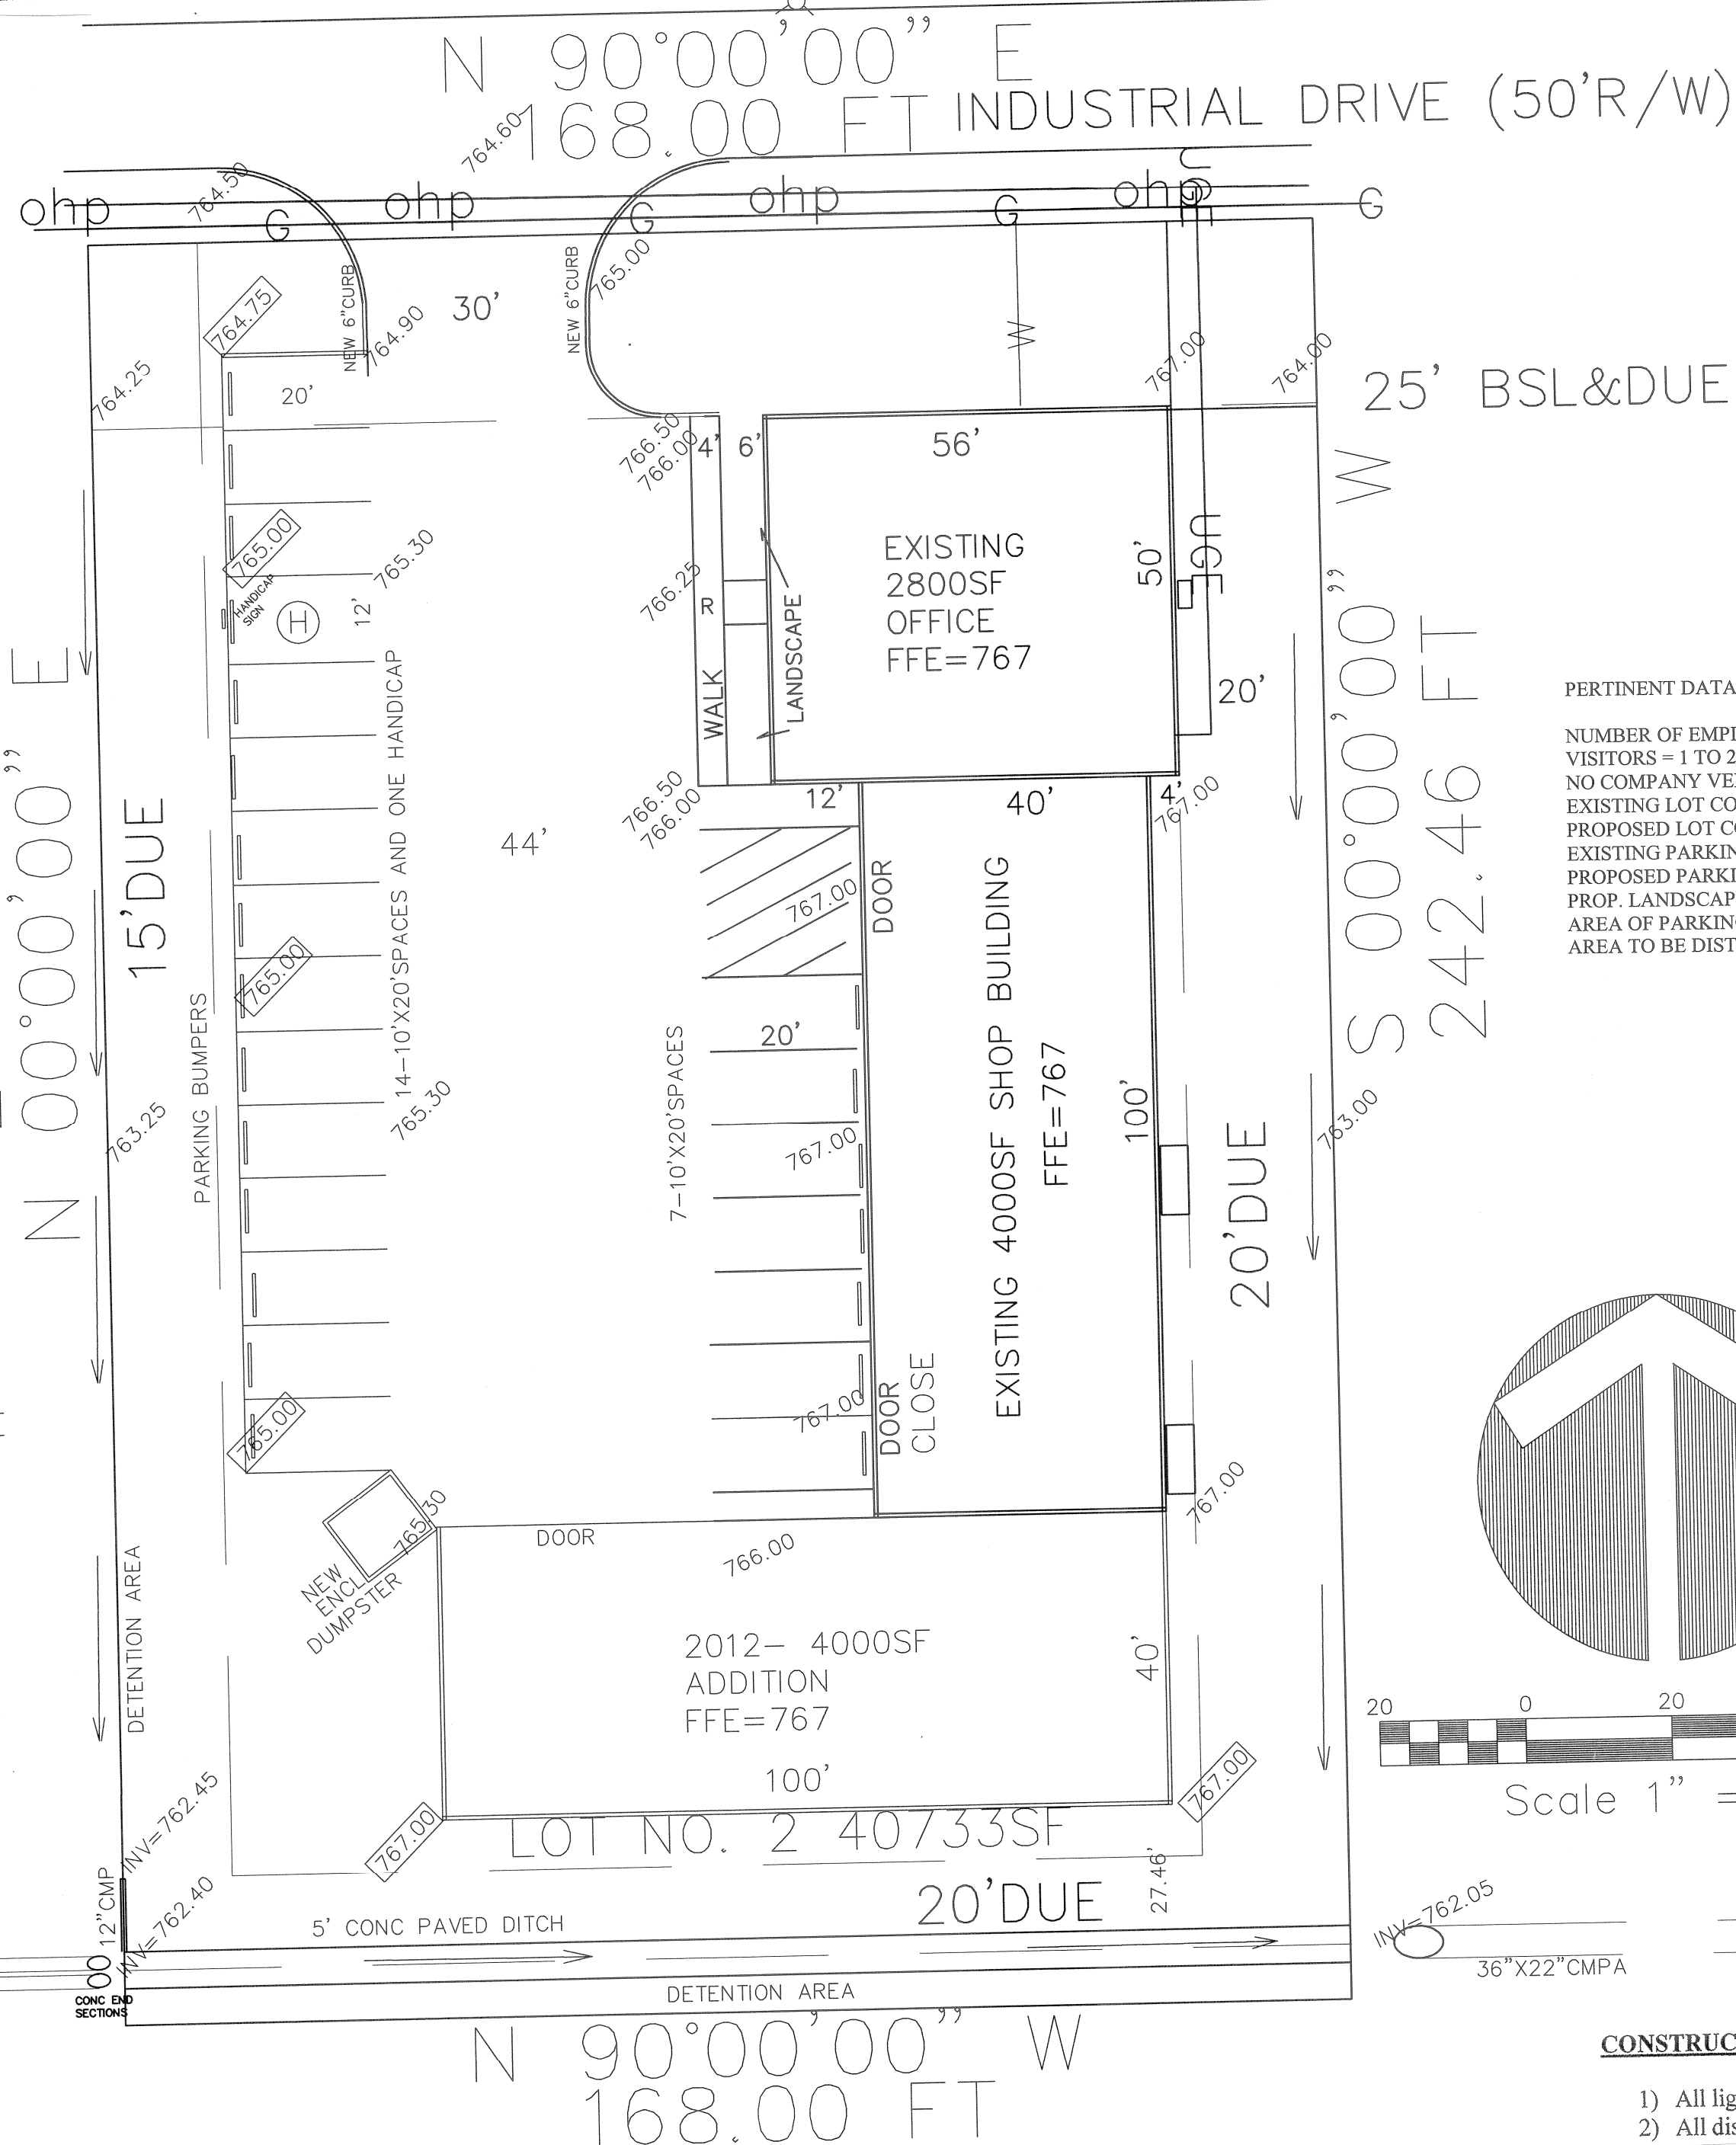

 
NUMBER OF EMPLOYEES = 20 (ONE SHIFT)  
VISITORS = 1 TO 2  
NO COMPANY VEHICLES  
EXISTING LOT COVERAGE = 42%  
PROPOSED LOT COVERAGE = 60%  
EXISTING PARKING SPACES = 19  
PROPOSED PARKING SPACES = 22  
PROP. LANDSCAPE AREA = 4275SF OR 40%  
AREA OF PARKING AND DRIVES = 10750SF  
AREA TO BE DISTURBED = 7500SF OR .17AC

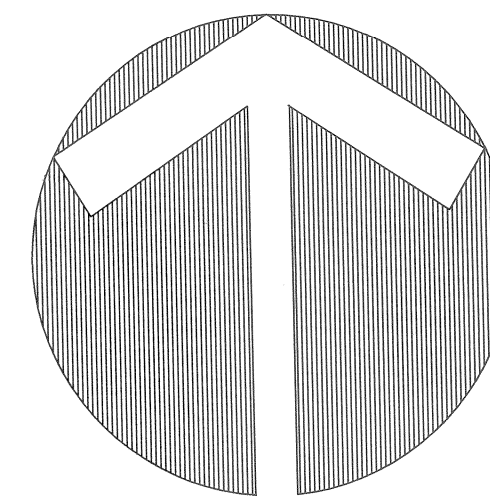

Scale 1" = 20'

INV=762.05  
36"X22" CMPA

- 1) All lighting used must be 90 degrees shielded down.
- 2) All disturbed areas must be permanently seeded.

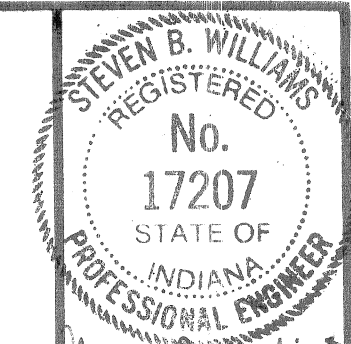

**CHECKED:**

PROPOSED SITE PLAN  
2012 BUILDING AND PARKING LOT ADDITION  
JIM STEVENS ENTERPRISES, LLC  
215 INDUSTRIAL DRIVE, FRANKLIN

Steven B. Williams

Engineering and Surveying  
2868 East 7th North

Whiteland, Indiana 46184  
Phone: 317-460-7730, Fax: 317-535-1864 384549

## REVISIONS

| DATE | REVISION |
|------|----------|
|      |          |
|      |          |

PROJ. NO: SW-451

SCALE:  $1'' = 20'$

DATE: 5-15-12

FILE NO:

SHT 3 OF 4

IKON N418028