




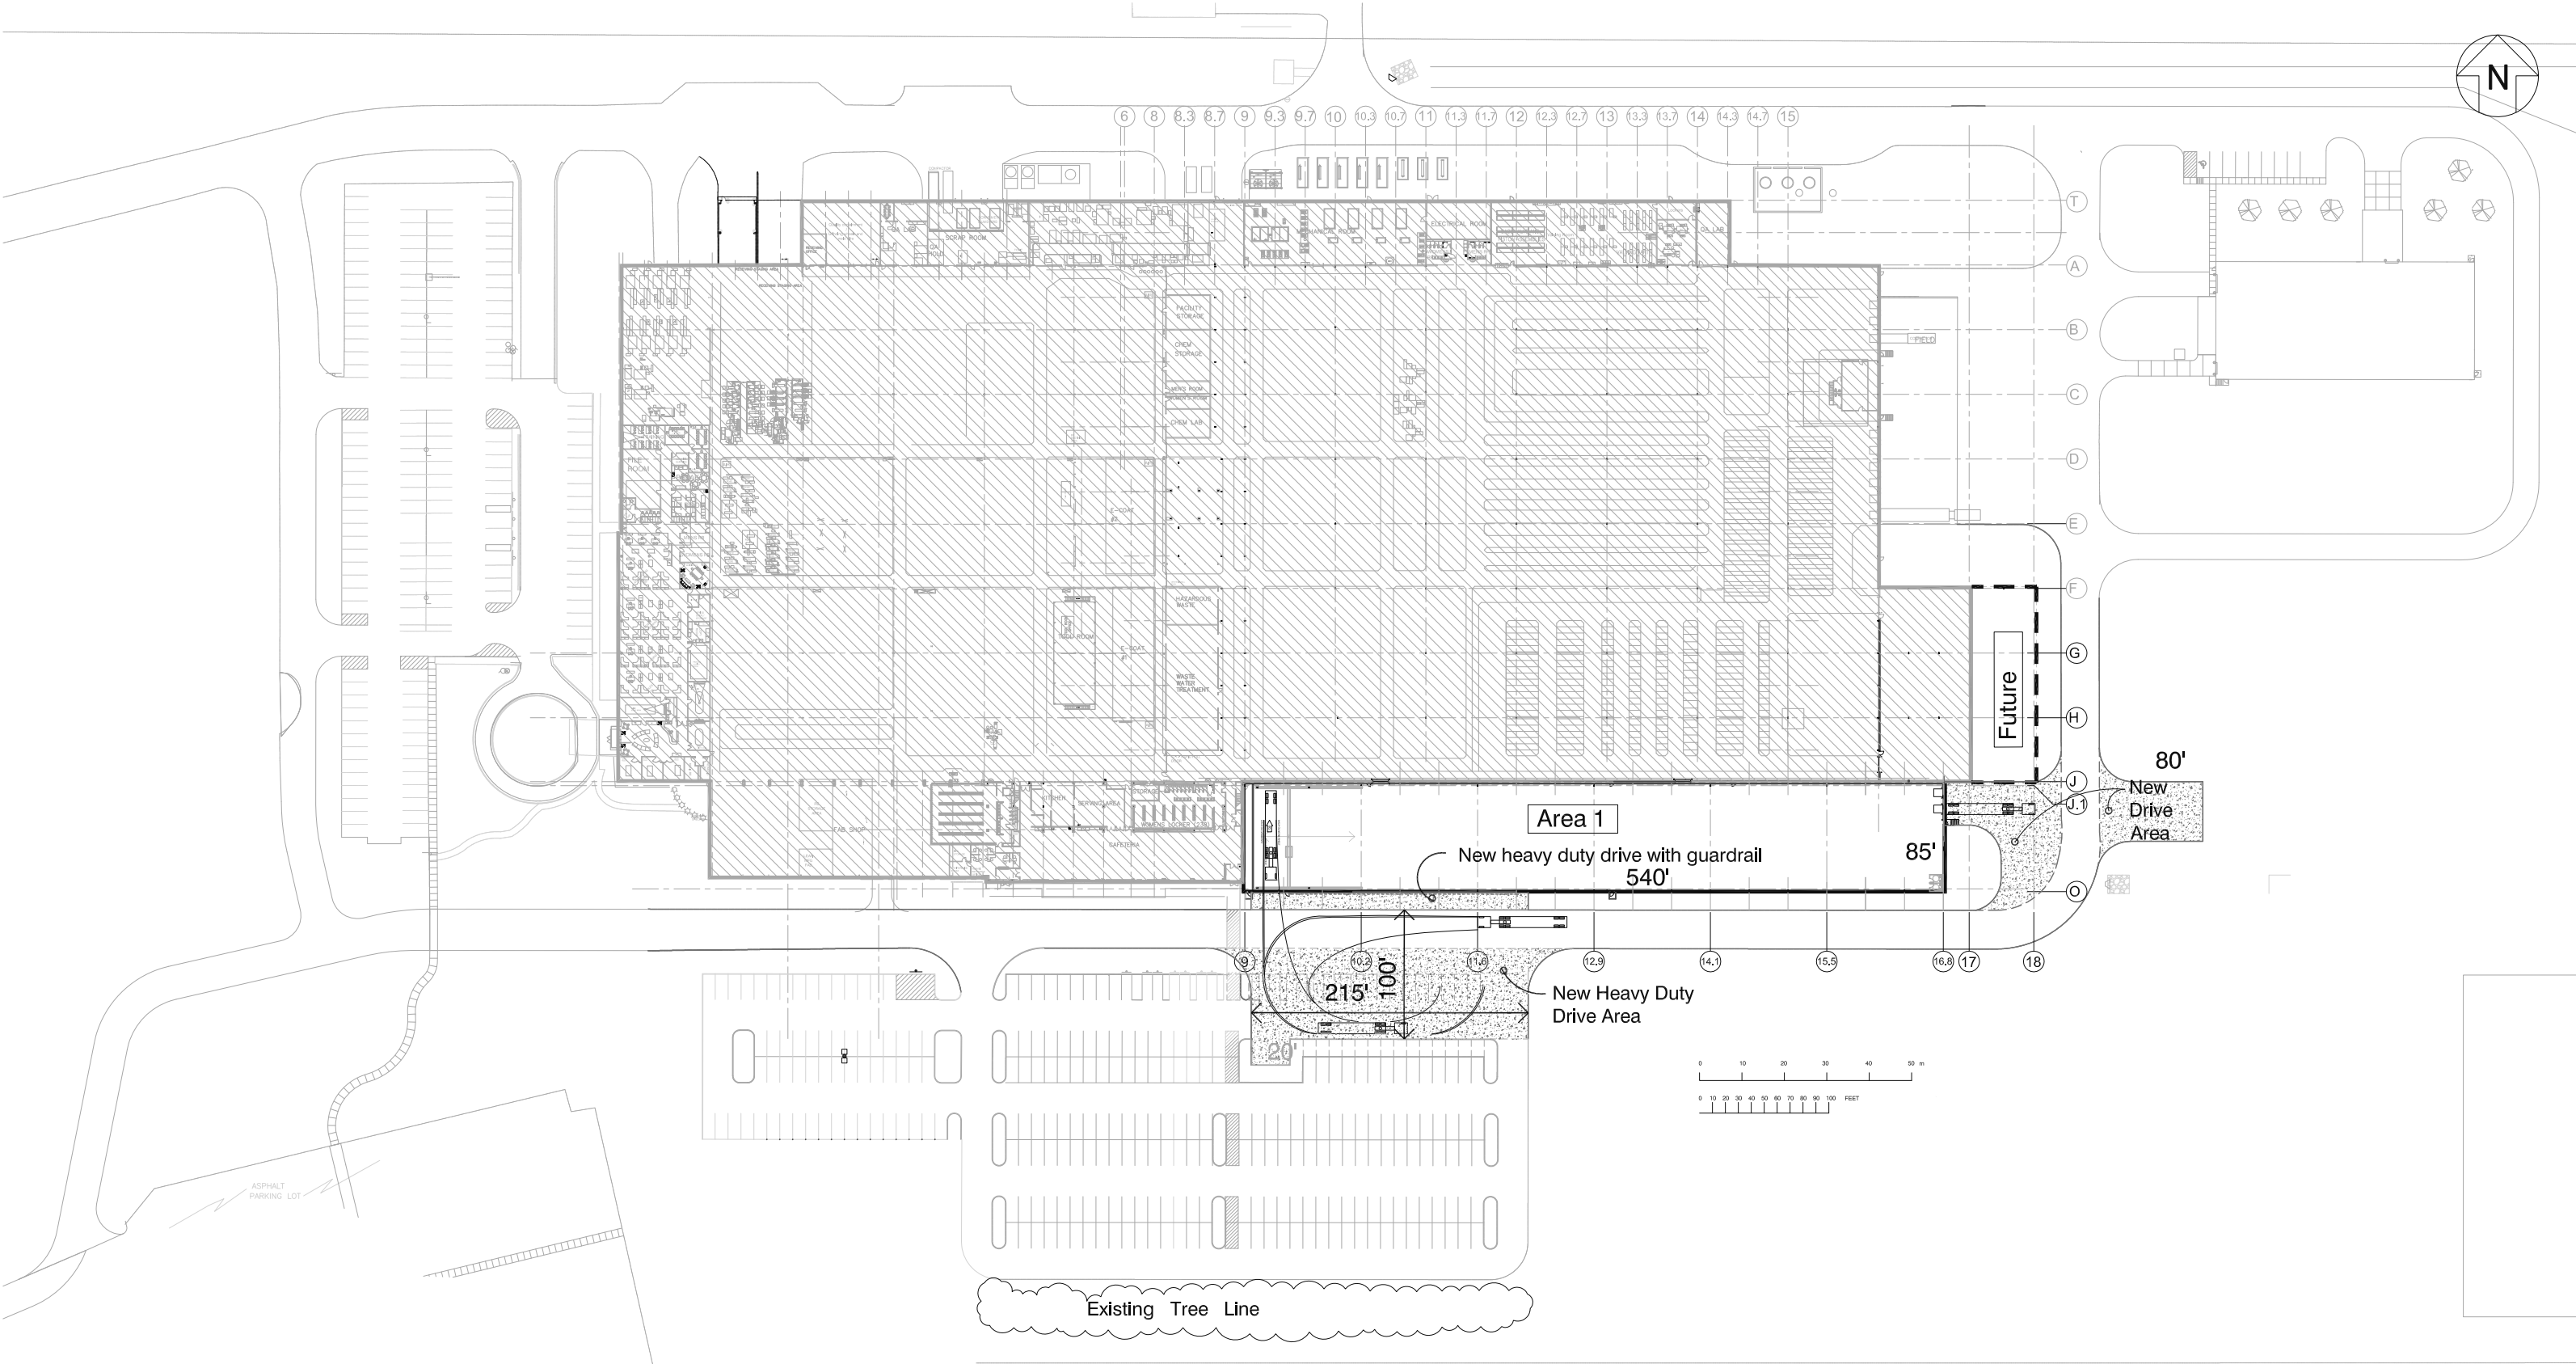

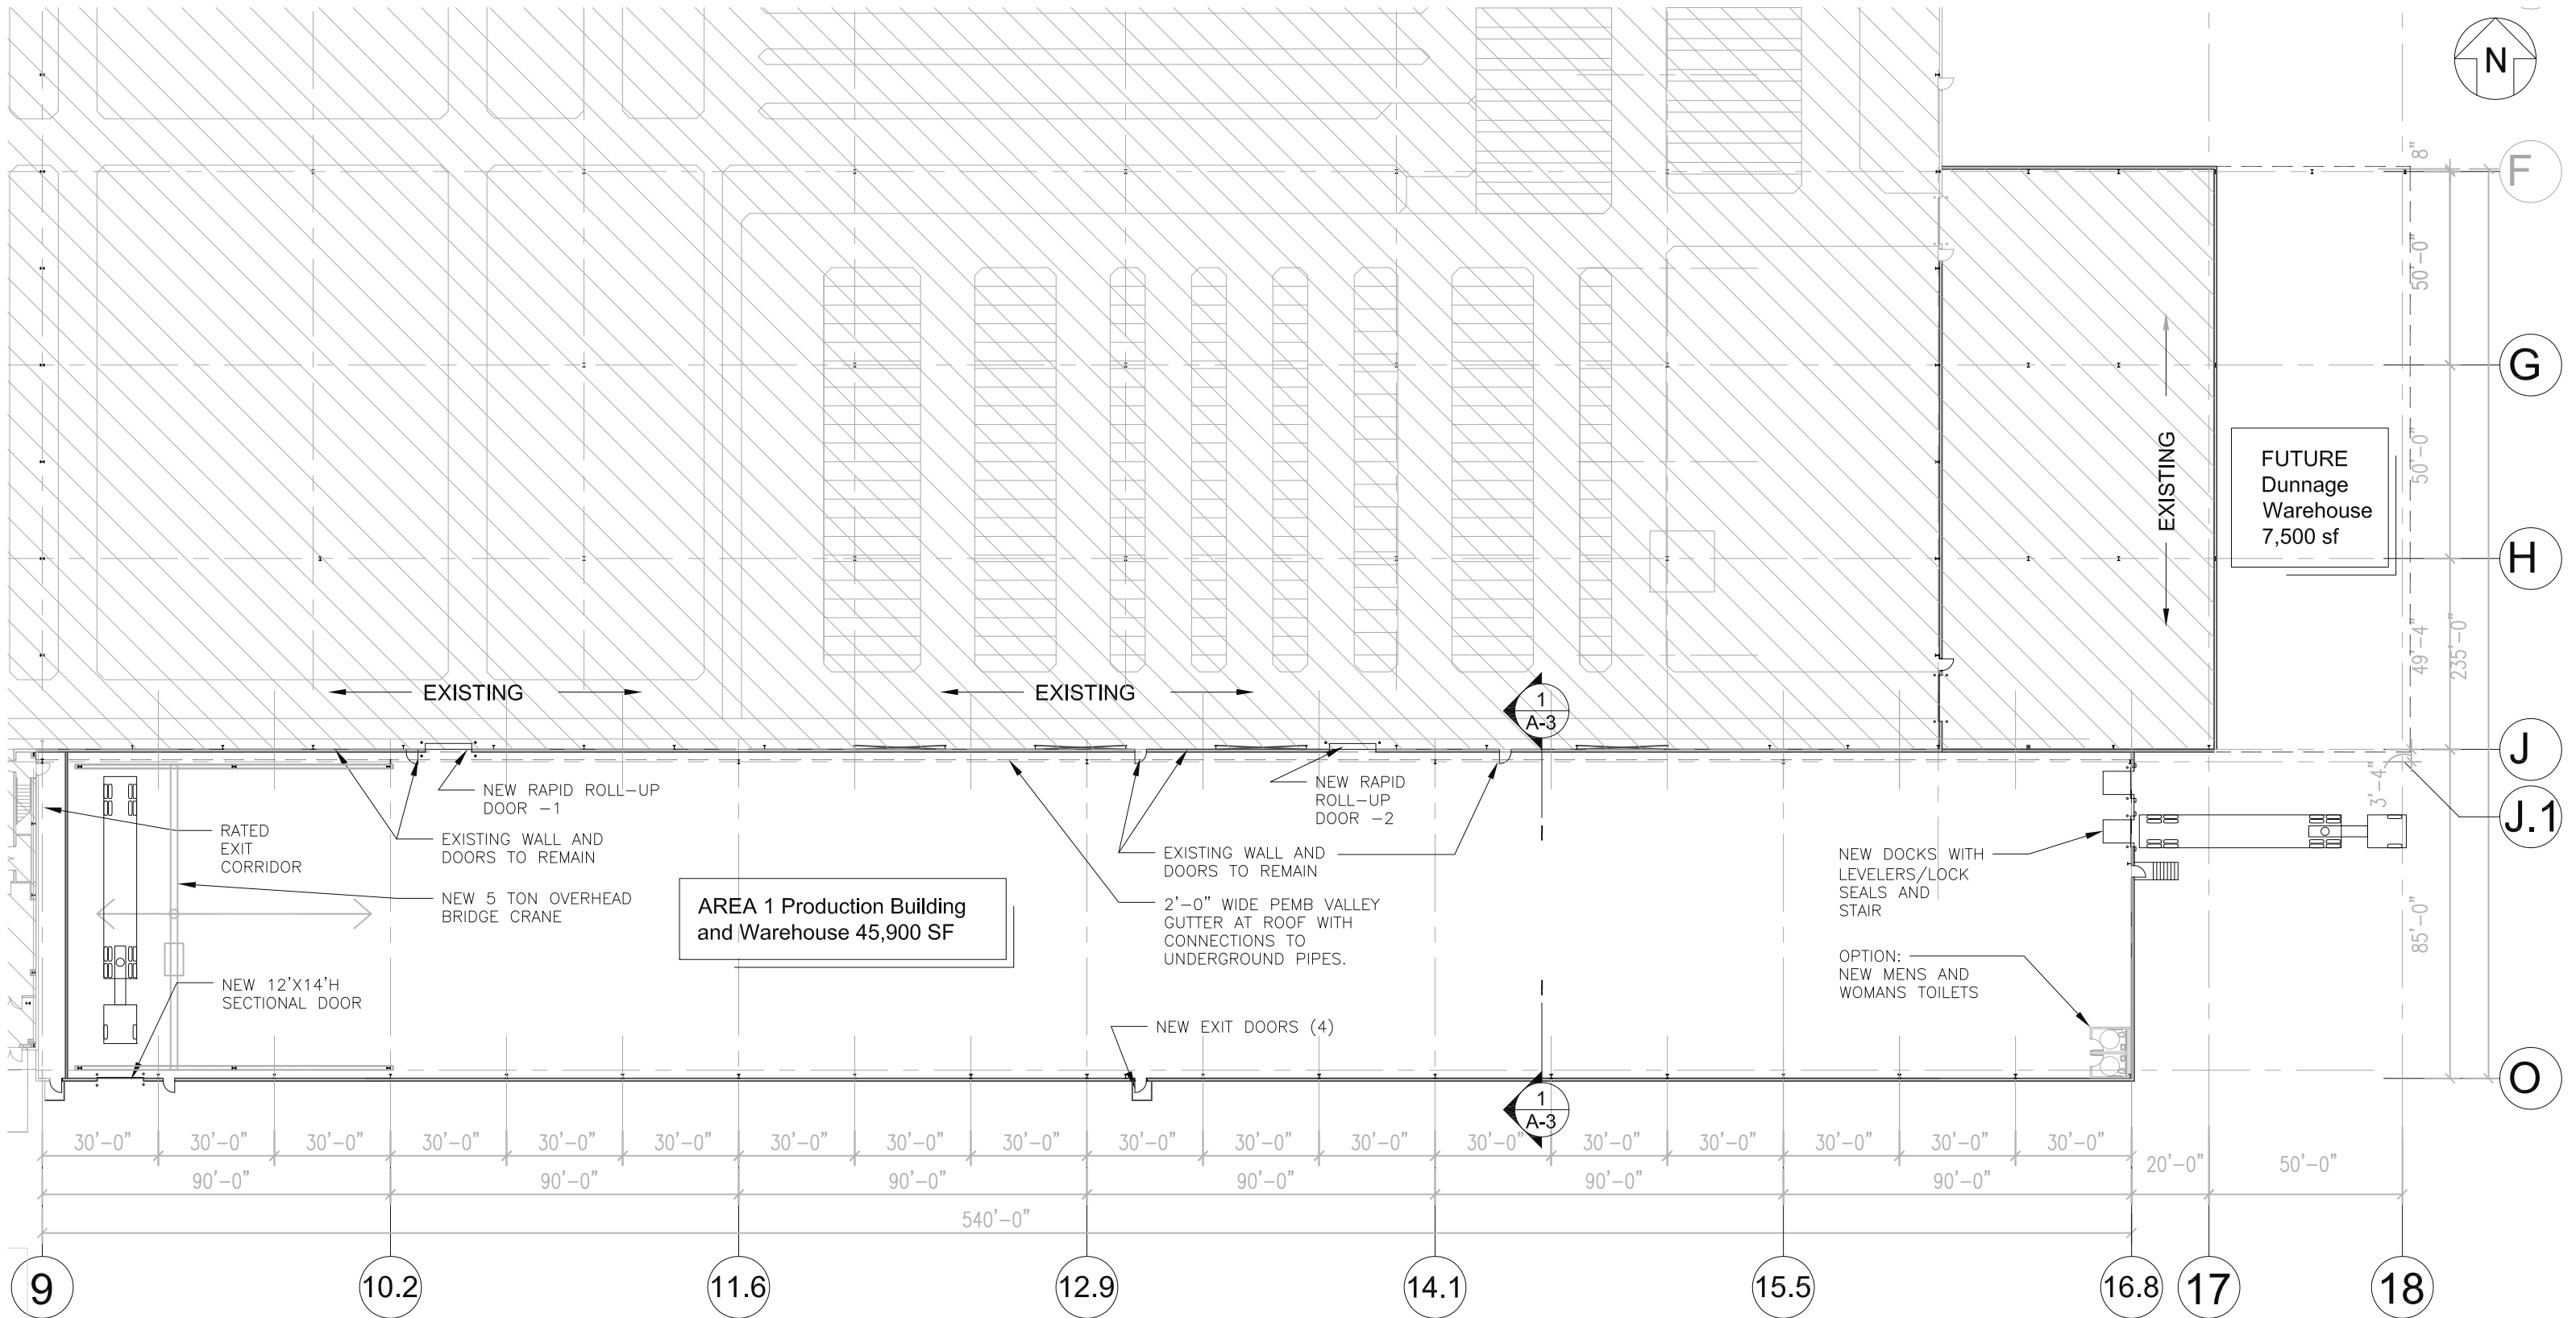

1 Partial Floor Plan
1/40" = 1'-0"

KYB Aftermarket Production Building Franklin, Indiana	TAKENAKA CORPORATION (USA) 56 South Park Boulevard Greenwood, Indiana 46143	DRAWING REVISIONS		DRAWING TITLE					DRAWING NO. A-2	
		NO.	DESCRIPTION	DATE	Partial Floor Plan					
					PROJECT No.	SCALE	DRAWN	CHECKED BY		DATE
					-	--	DTI	KF		07/23/13
Copyright © 2013 Takenaka Corporation (USA)										

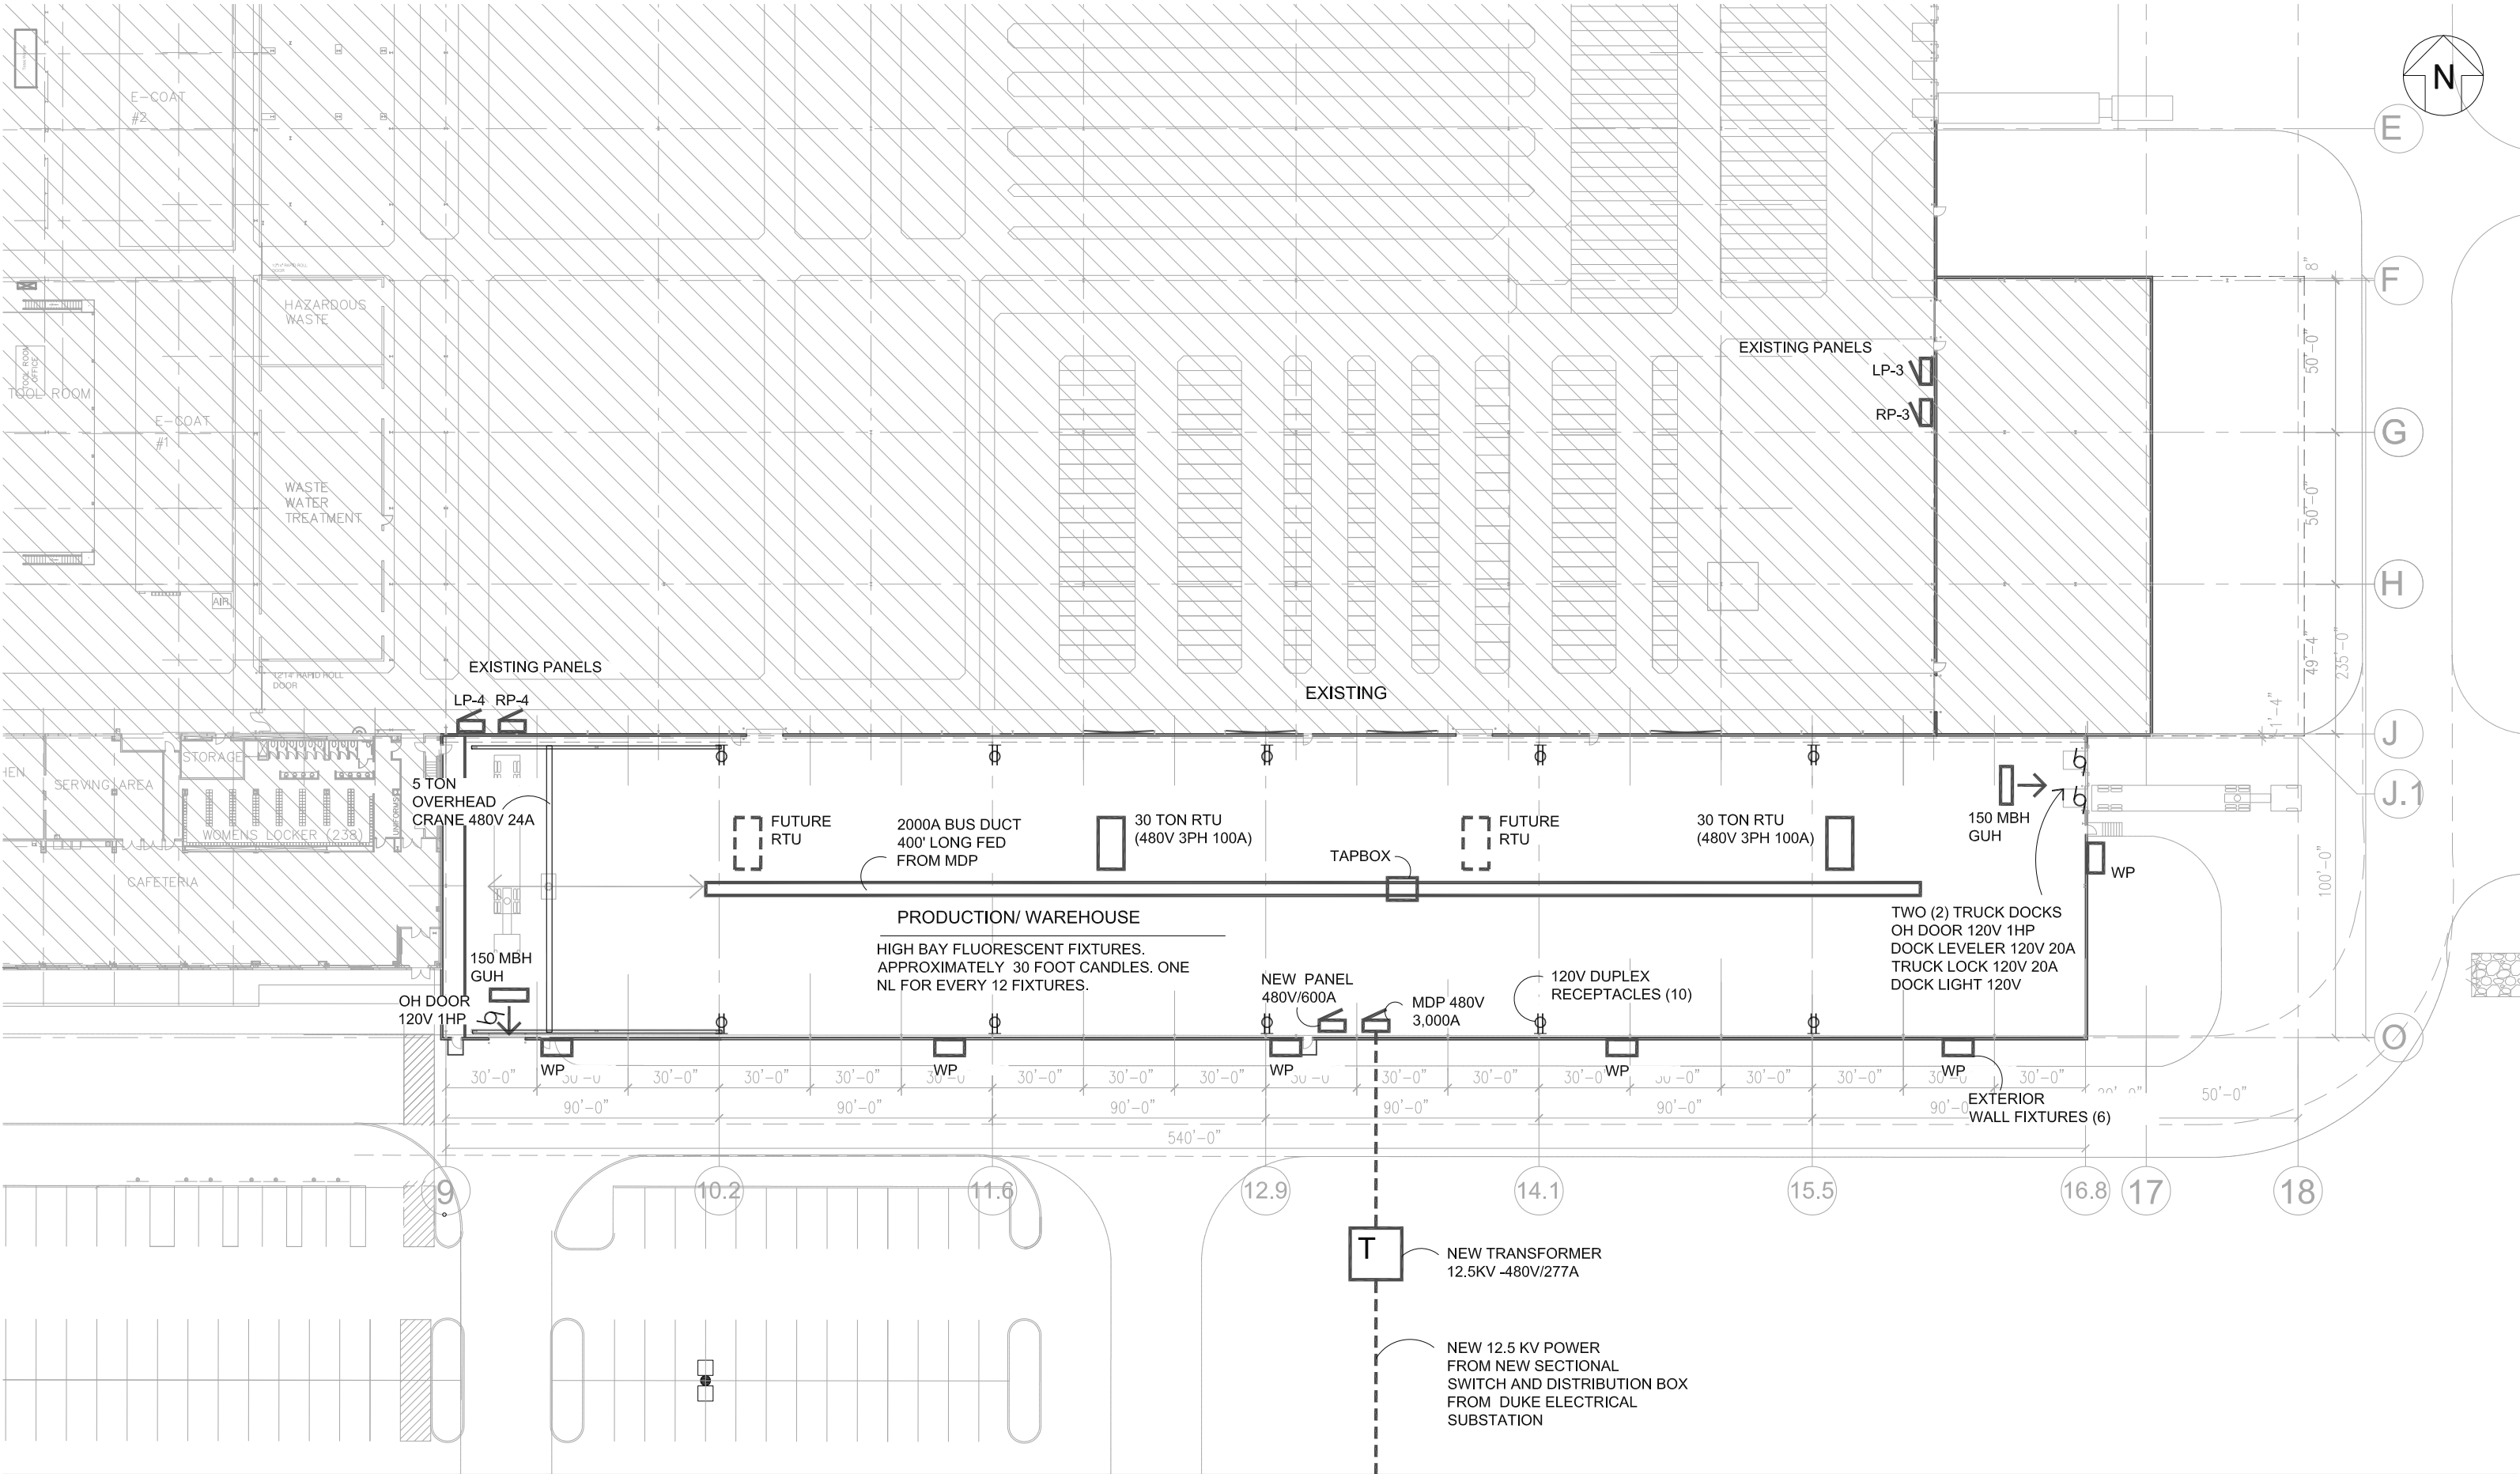

KYB Aftermarket Production Building Franklin, Indiana	TAKENAKA CORPORATION (USA) 56 South Park Boulevard Greenwood, Indiana 46143	DRAWING REVISIONS		DRAWING TITLE					DRAWING NO. E-1	
		NO.	DESCRIPTION	DATE	Electrical Site Plan					
		PROJECT No.		SCALE	DRAWN	CHECKED BY	DATE			
		-		1"=50'-0"	DTI	DTI	07/23/13			